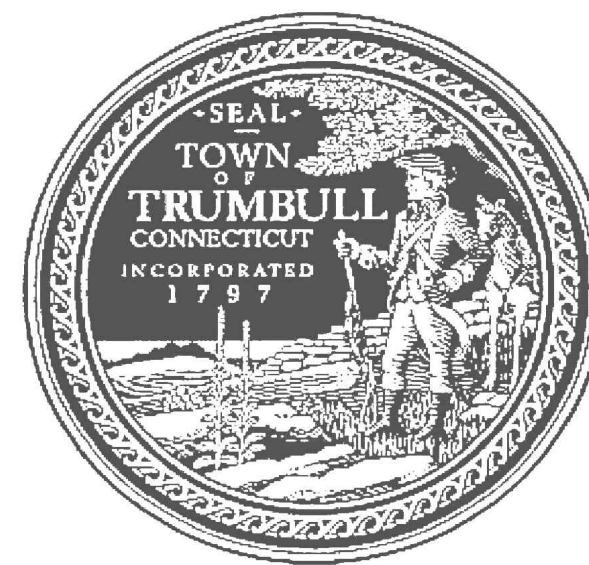


TOWN OF TRUMBULL

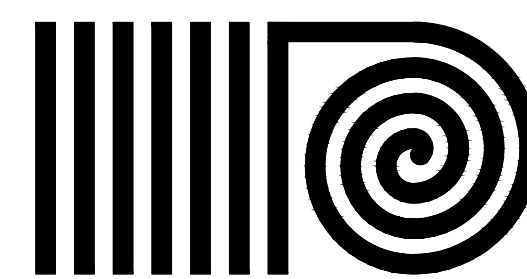


MIDDLEBROOK ELEMENTARY SCHOOL FUEL OIL TANK REPLACEMENT

220 MIDDLEBROOKS AVENUE
TRUMBULL, CONNECTICUT

DATE: 16 JULY 2013

ISSUED FOR BID: 08 APRIL 2014



ANTINOZZI ASSOCIATES

ARCHITECTURE & INTERIORS

271 Fairfield Avenue
Bridgeport, Connecticut 06604

TEL (203) 377-1300 FAX (203) 378-3002

**ELECTRICAL & MECHANICAL
ENGINEER:**

 
 
 
 
 
 
 
 
 
 
 
 
 
 
 
 
 
 
 
 
 
 
 
 
 
 
AKF

750 EAST MAIN ST., SUITE 501
STAMFORD, CT 06902
PHONE: (203) 323-4333
www.AKfgroup.com






MECHANICAL SYMBOL LIST

(NOT ALL SYMBOLS ARE NECESSARILY USED ON THIS PROJECT)



HVAC PIPING SYMBOLS

	NEW PIPE WITH DIRECTION OF FLOW
	EXISTING PIPING
	EXISTING PIPING/EQUIPMENT TO BE REMOVED
	PIPE DROP
	PIPE RISE
	PITCH UP IN DIRECTION OF FLOW
	PITCH DOWN IN DIRECTION OF FLOW
	UNION
	CONCENTRIC REDUCER
	ECCENTRIC REDUCER – FLAT BOTTOM
	ECCENTRIC REDUCER – FLAT TOP
	FLANGED CONNECTION
	FLANGED END – BLIND FLANGE
	DEAD END – SCREWED CAP
	DEAD END – WELDED CAP
	EXPANSION LOOP
	PIPE EXPANSION JOINT
	BALL JOINT
	PIPE ALIGNMENT GUIDE
	PIPE ANCHOR
	GATE VALVE
	ANGLE GATE VALVE
	GLOBE VALVE
	ANGLE GLOBE VALVE
	NEEDLE VALVE COCK
	DRAIN VALVE
	LOCK SHIELD VALVE
	CHECK VALVE, SWING OR LIFT
	SILENT CHECK (NON-SLAM) VALVE
	FLEXIBLE CONNECTOR
	BUTTERFLY VALVE
	BALL VALVE
	SQUARE HEAD COCK
	BALANCING VALVE
	PLUG VALVE (TYPE AS NOTED)
	AUTOMATIC CONTROL VALVE
	THREE-WAY AUTOMATIC CONTROL VALVE
	FLOW CONTROL VALVE
	QUICK CLOSING VALVE WITH FUSIBLE LINK
	QUICK OPENING VALVE
	DIAPHRAGM VALVE

     HVAC PIPING SYMBOLS CONT'D

	SOLENOID VALVE
	ELECTRIC MOTORIZED VALVE OPERATOR
	THERMOMETER WELL
	THERMOMETER AND WELL
	PRESSURE GAUGE WITH SYPHON
	PUMP
	PUMP SUCTION DIFFUSER
	SEPARATOR
	FILTER, IN LINE
	FLOW METER
	FUEL LEVEL GAUGE
	FUEL OIL FILL
	FUEL OIL GAUGE
	FUEL OIL RETURN
	FUEL OIL SUPPLY
	FUEL OIL VENT

  HVAC GENERAL SYMBOLS

	POINT OF CONNECTION
	POINT OF DISCONNECTION
	SECTION DESIGNATION
	SHEET NO. WHERE SECTION IS SHOWN
	DETAIL DESIGNATION
	SHEET NO. WHERE SECTION IS SHOWN

ABBREVIATIONS

(NOT ALL ABBREVIATIONS ARE NECESSARILY USED ON THIS PROJECT)

AF	AFTER FILTER	LF, LIN.FT.	LINEAR FEET
AFF	ABOVE FINISHED FLOOR	LR	LINEAR RETURN
BFP	BOILER FEED PUMP	LRA	LOCKED ROTOR AMPS
BHP	BRAKE HORSEPOWER	LV	LOW VELOCITY
BTU	BRITISH THERMAL UNIT	MAX	MAXIMUM
BTUH	BTU PER HOUR	MBH	THOUSAND BTU PER HOUR
°C	DEGREES CENTIGRADE (CELSIUS)	MCC	MOTOR CONTROL CENTER
C	CONVERTOR	MER	MECHANICAL EQUIPMENT ROOM
CAC	CONTROL AIR COMPRESSOR	MHP	MOTOR HORSEPOWER
CCP	CENTRAL CONTROL PANEL	MIN	MINIMUM
CCW	COUNTER CLOCKWISE	MM	MILLIMETER
CCFC	CAP FOR FUTURE CONNECTION	MOT	MOTOR
COMPR	COMPRESSOR	MOV	MOTOR OPERATED VALVE
COND	CONDENSATE	NC	NORMALLY CLOSED
CPA	CONTROL POINT ADJUSTMENT	NIC	NOT IN CONTRACT
CV	CONSTANT VOLUME	N.O.	NORMALLY OPEN
CW	CLOCKWISE	N.O.	NUMBER
D	DROP	NTS	NOT TO SCALE
DBD	DOWN BLAST DISCHARGE	OD	OUTSIDE DIAMETER
DIAM	DIAMETER	OV	OUTLET VELOCITY
DN	DOWN	P	PUMP
DWG	DRAWING	PCC	PRE-COOLING COIL
(E)	EXISTING TO REMAIN	PD	PRESSURE DROP
EA	EACH	PF	PRE-FILTER
EL	ELEVATION	PHC	PREHEAT COIL
EQ	EQUAL	PRV	PRESSURE REDUCING VALVE
(ER)	EXISTING TO BE REMOVED	PSI	POUNDS PER SQUARE INCH
(ERR)	EXISTING TO BE REMOVED & RELOCATED	PSIA	PSI ABSOLUTE
EXIST	EXISTING	PSIG	PSI GAUGE
F	FILTER	R	RISE
°F	DEGREES FAHRENHEIT	RAD	RADIATION
FA	FREE AREA (SQ.FT.)	RCC	RECOOLING COIL
FF	FINAL FILTER	RHC	REHEAT COIL
FG	FINISHED GRADE	RM	ROOM
FIN FL	FINISHED FLOOR	ROT	ROTATION
FOP	FUEL OIL PUMP	RPM	REVOLUTIONS PER MINUTE
FOT	FUEL OIL TANK	(RE)	EXISTING TO BE REMOVED AND RETURN TO OWNER
FPM	FEET PER MINUTE	SPEC	SPECIFICATION
FPS	FEET PER SECOND	SQ.FT.	SQUARE FEET
FT	FEET	SS	STAINLESS STEEL
FV	FACE VELOCITY	T	THROAT
G	GAUGE	TEMP	TEMPERATURE
GAL	GALLON	TT	TOP THROAT
GPH	GALLONS PER HOUR	TYP	TYPICAL
GPM	GALLONS PER MINUTE	UON	UNLESS OTHERWISE NOTED
HR	HOURL	W	WIDTH
HT	HEIGHT	W/	WITH
IN	INCH OR INCHES	W/O	WITHOUT
IPS	IRON PIPE SIZE	WP	WORKING PRESSURE
L	LENGTH		
LBS	POUNDS		

GENERAL NOTES

- GENERAL NOTES, SYMBOLS, ABBREVIATIONS, AND DETAILS ARE APPLICABLE TO ALL HVAC/MECHANICAL DRAWINGS.
- DRAWINGS ARE DIAGRAMMATIC. DETERMINE LOCATIONS OF SYSTEMS AND COMPONENTS IN FIELD. RELOCATE EXISTING WORK THAT INTERFERES WITH WORK OF THIS CONTRACT.
- COORDINATE THIS WORK WITH THAT OF OTHER TRADES.
- DIMENSIONS SHOWN ON PLAN ARE HORIZONTAL. DIMENSIONS SHOWN IN ELEVATION ARE VERTICAL, EXCEPT IN WAY OF STRUCTURAL STEEL, DIMENSIONS ARE MEASURED PERPENDICULAR TO FLANGE.
- NEITHER ACCURACY NOR COMPLETION OF SERVICES AND UTILITY LOCATIONS SHOWN ON DRAWINGS IS GUARANTEED. DETERMINE EXACT LOCATIONS OF EXISTING SERVICES AND UTILITIES IN FIELD, WHETHER OR NOT SHOWN ON DRAWINGS. EXERCISE CAUTION AND IDENTIFY LOCATIONS OF UNMARKED UTILITY LINES AS NECESSARY TO PERFORM WORK OF THIS SECTION.
- MANUFACTURERS MODEL NUMBERS ARE SPECIFIED SOLELY TO ESTABLISH STANDARDS OF QUALITY FOR PERFORMANCE AND MATERIALS.
- PRODUCT INSTALLATION SHALL ADHERE TO MANUFACTURERS RECOMMENDATIONS.
- PROVIDE ACCESS PANELS IN IN ACCORDANCE WITH MANUFACTURERS' RECOMMENDATIONS FOR ALL CONCEALED EQUIPMENT THAT REQUIRES PERIODIC SERVICE.
- PROVIDE HANGERS, INSERTS, ANCHORS, SUPPLEMENTAL STEEL & SUPPORTS AS REQUIRED TO SUPPORT DUCTWORK, PIPING AND EQUIPMENT FROM STRUCTURE.
- SCHEDULE WORK OF THIS SECTION TO AVOID INTERFERING WITH EXISTING OPERATIONS IN THE FACILITY.
- RUN DUCTS AND PIPING CONCEALED, UNLESS OTHERWISE SPECIFIED, AND CLEAR OF CEILING INSERTS.
- PROVIDE 36" CLEARANCE IN FRONT OF ALL ELECTRIC CONTROL PANELS PER N.E.C. AND EQUIPMENT MANUFACTURERS' REQUIREMENTS.
- STRUCTURAL WELDING SHALL BE CONTINUOUS 1/4" FILLET UNLESS REQUIRED OTHERWISE.
- ALL MOTOR STARTERS FOR HVAC EQUIPMENT SHALL BE FURNISHED BY THE MECHANICAL CONTRACTOR AND INSTALLED/WIRED BY THE ELECTRICAL CONTRACTOR, UNLESS OTHERWISE NOTED.
- ALL DISCONNECT SWITCHES FOR HVAC EQUIPMENT SHALL BE FURNISHED, INSTALLED, AND WIRED BY THE ELECTRICAL CONTRACTOR, UNLESS OTHERWISE NOTED.
- THE PERMANENT HVAC AIR EQUIPMENT SHALL NOT BE USED BY ANY CONTRACTOR DURING CONSTRUCTION FOR TEMPORARY HEATING, COOLING, OR VENTILATION. IF TEMPORARY HEATING, COOLING, OR VENTILATION IS REQUIRED AT ANY POINT DURING CONSTRUCTION, THE CONTRACTOR SHALL PROVIDE TEMPORARY HEATING, COOLING, OR VENTILATION EQUIPMENT, DUCTWORK, CONTROLS, PIPING, AND POWER AT HIS OWN EXPENSE.
- DURING CONSTRUCTION, THE OWNER'S PERMANENT HVAC AIR EQUIPMENT SHALL BE PROTECTED FROM DUST AND DEBRIS. COVER ALL OPENINGS WITH HEAVY POLYETHYLENE PLASTIC AND TAPE AIR TIGHT. WHEN GENERAL CONSTRUCTION IS COMPLETE, VACUUM CLEAN INSIDE OF UNITS AND REMOVE ANY CONSTRUCTION DEBRIS.
- PORTIONS OF THE AREAS TO BE RETROFITTED WERE NOT ACCESSIBLE AND/OR NOT DEMOLISHED UNTIL AFTER THE DESIGN PERIOD. WITHOUT THE SPACE BEING COMPLETELY ACCESSIBLE AND/OR DEMOLISHED DURING THE DESIGN PERIOD, WE WERE NOT BE ABLE TO SURVEY THE EXTENT OF THE EXISTING CONDITIONS AND ALL OF THE SERVICES AND CONDITIONS THAT MAY EXIST FOR CONFLICTS WITH THE INTENDED PROGRAM. THERE MAY BE COORDINATION ITEMS THAT WILL NEED TO BE ADDRESSED AFTER DEMOLITION DURING THE CONSTRUCTION PERIOD. IT SHOULD BE NOTED THAT A FINAL REVIEW AND COORDINATION WILL BE REQUIRED AFTER DEMOLITION TO VERIFY ALL FIELD CONDITIONS WITH THE DESIGN DOCUMENTS. THIS MAY RESULT IN CONSTRUCTION COST CHANGES.

PIPING SYSTEMS

- PITCH PIPING 1" IN 20' IN DIRECTION OF FLOW.

DEMOLITION NOTES

- GENERAL
 - THIS CONTRACTOR SHALL VISIT THE SITE AND ADJOINING AREAS AND EXAMINE THE EXISTING CONDITIONS TO BECOME FAMILIAR WITH THEM AND TO DETERMINE THE DIFFICULTIES WHICH WILL AFFECT THE EXECUTION OF THE WORK OF THIS CONTRACT. THIS CONTRACTOR SHALL PERFORM THIS PRIOR TO THE SUBMISSION OF HIS OR HER PROPOSAL. SUBMISSION OF A PROPOSAL WILL BE CONSTRUED AS EVIDENCE THAT SUCH AN EXAMINATION HAS BEEN MADE AND LATER CLAIMS WILL NOT BE RECOGNIZED FOR EXTRA LABOR, EQUIPMENT OR MATERIALS REQUIRED BECAUSE OF DIFFICULTIES ENCOUNTERED WHICH COULD HAVE BEEN FORESEEN HAD SUCH AN EXAMINATION BEEN MADE.
 - THE DEMOLITION WORK SHALL INCLUDE, PROVIDING ALL MATERIALS, ALL NECESSARY EXTENSIONS, CONNECTIONS, CUTTING, REPAIRING, ADAPTING AND OTHER MECHANICAL WORK REQUIRED, TOGETHER WITH ANY REQUIRED TEMPORARY CONNECTIONS TO MAINTAIN SERVICE PENDING THE COMPLETION OF THE PERMANENT WORK. NOTES AND GRAPHIC REPRESENTATION SHALL NOT LIMIT THE EXTENT OF DEMOLITION REQUIRED. EXTENT OF DEMOLITION WORK SHALL BE COORDINATED WITH THE ARCHITECT AND BUILDING MANAGEMENT.
- SCOPE OF WORK
 - ALL EXISTING WORK REQUIRED TO REMAIN BUT INTERFERING WITH PROPOSED NEW MECHANICAL (AS WELL AS ELECTRICAL AND GENERAL CONSTRUCTION WORK) SHALL BE RELOCATED AND RECONNECTED USING MATERIALS CONFORMING TO STANDARDS OF THIS CONTRACT.
 - FOR EXISTING EQUIPMENT TO BE REMOVED, REMOVE ALL STARTERS, DISCONNECT SWITCHES, MOTORS, CONTROL (BOTH TEMPERATURE AND SYSTEM CONTROL) BACK TO MAIN PANELS AND CAP AT PANEL. COORDINATE WITH ELECTRICAL CONTRACTOR BEFORE REMOVAL OF ANY ELECTRICAL POWERED EQUIPMENT. ELECTRICAL CONTRACTOR IS TO DISCONNECT ALL POWER TO SUCH EQUIPMENT. REMOVE ALL ASSOCIATED BRANCH PIPING AND BRANCH DUCTWORK BACK TO MAINS OR AS SHOWN ON PLAN.
 - CONTRACTOR TO REPLACE/PATCH WALLS AND FLOORS TO MATCH EXISTING.
 - PROVIDE ADDITIONAL SUPPORT FOR ALL EXISTING DUCTS AND PIPING TO REMAIN WHICH ARE AFFECTED BY DEMOLITION OF EXISTING CEILING AND PARTITIONS.
 - EQUIPMENT REQUIRED TO BE TURNED OVER TO THE OWNER SHALL BE PLACED IN A MUTUALLY ACCEPTABLE LOCATION. ALL MATERIALS AND EQUIPMENT REMOVED AS A RESULT OF DEMOLITION SHALL BE TAKEN FROM THE SITE AND DISPOSED OF IN ACCORDANCE WITH APPLICABLE LAWS AND ENVIRONMENTAL REGULATIONS.
 - CONTRACTOR SHALL IDENTIFY ALL EXISTING WORK TO REMAIN BY ACCEPTABLE IDENTIFICATION MEANS TO CONFIRM PROPER SCOPE PRIOR TO COMMENCEMENT OF DEMOLITION.

PRICING ALTERNATES

- PRICING ALTERNATE #M1:** REMOVE THE EXISTING FUEL OIL PUMP AND ELECTRIC OIL HEATER. PROVIDE A NEW PACKAGED SKID-MOUNTED DUPLEX FUEL OIL PUMP SET WITH MANUFACTURER SUPPLIED CONTROLS.
- PRICING ALTERNATE #M2:** PROVIDE A NEW 6,000 GALLON BURIED FUEL OIL TANK, INSTEAD OF A NEW 15,000 GALLON BURIED FUEL OIL TANK AS SPECIFIED UNDER BASE BID SCOPE.
- PRICING ALTERNATE #M3:** PROVIDE A NEW 3,000 GALLON OUTDOOR ABOVE-GROUND FUEL OIL TANK, INSTEAD OF A NEW 15,000 GALLON BURIED FUEL OIL TANK AS SPECIFIED UNDER BASE BID SCOPE.
- PRICING ALTERNATE #M4:** DO NOT PROVIDE A NEW FUEL TANK, PIPING, OR FILL/LEAK/LEVEL CONTROLS. JUST REMOVE THE EXISTING TANK, PIPING, AND FILL/LEAK/LEVEL CONTROLS AND PROVIDE RESTORATIVE WORK (BACKFILL, GRADING, TOPSOIL, SEEDING, ETC.), AS INDICATED ON DRAWING M-200.

UNIT PRICING


- UNIT PRICE #M1:** PROVIDE A UNIT PRICE (\$/TON) TO EXCAVATE, REMOVE, AND DISPOSE OF CONTAMINATED SOIL IN ACCORDANCE WITH ALL STATE, LOCAL, AND FEDERAL LAWS AND CODES. THIS UNIT PRICE SHALL ALSO INCLUDE PROVIDING CLEAN BACKFILL TO REPLACE THE SOIL WHICH WAS REMOVED.

DRAWING INDEX	
DRAWING NO.	DRAWING TITLE
M-100	MECHANICAL COVER SHEET
M-200	MECHANICAL DEMOLITION PLANS
M-300	MECHANICAL NEW WORK PLANS
M-400	MECHANICAL SCHEDULES AND DETAILS
M-500	MECHANICAL SPECIFICATIONS

AKF

750 East Main Street, Suite 501
Stamford, CT 06902
T: 203.323.4333 F: 203.323.2999

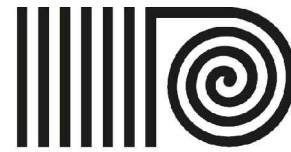ARLINGTON / BOSTON / MEXICO CITY / MINNEAPOLIS / NEW YORK
PHILADELPHIA / PRINCETON / ROCHESTER / STAMFORD
ENGINEERING / ANALYSIS & DESIGN / BUILDING MANAGEMENT SYSTEMS / CENTRAL SERVICES
CODE CONSULTING / CONSTRUCTION / OPERATIONAL SYSTEMS / FINANCIAL & SUSTAINABILITY
HUMAN RESOURCES / LEADERSHIP / DESIGN DESIGN / SPECIAL SERVICES
www.akfassociates.com



ANTINOZZI ASSOCIATES
ARCHITECTURE & INTERIORS

OWNER

Trumbull Public Schools
6254 Main Street
Trumbull, CT 06611

4	04/08/2014	ISSUED FOR BID
3	03/07/2014	ISSUED FOR BID
2	09/13/2013	ISSUED FOR BID
1	07/16/2013	ISSUED FOR REVIEW
No.	Date	Description

ISSUE

PROJECT
Fuel Oil Tank Replacement
Middlebrook Elementary School
220 Middlebrooks Ave.
Trumbull, CT 06611

DRAWING TITLE

MECHANICAL
COVER SHEET


Drawn By	JR	Drawing No. M-100
Checked By	JM	
Date	07/16/2013	
Scale	N.T.S.	
Project No.	S130020-000	

SAVE DATE: 4/8/2014 10:18 AM

PLOT DATE: 4/8/2014 11:01 AM


LOGIN: Reiss, Jeremy

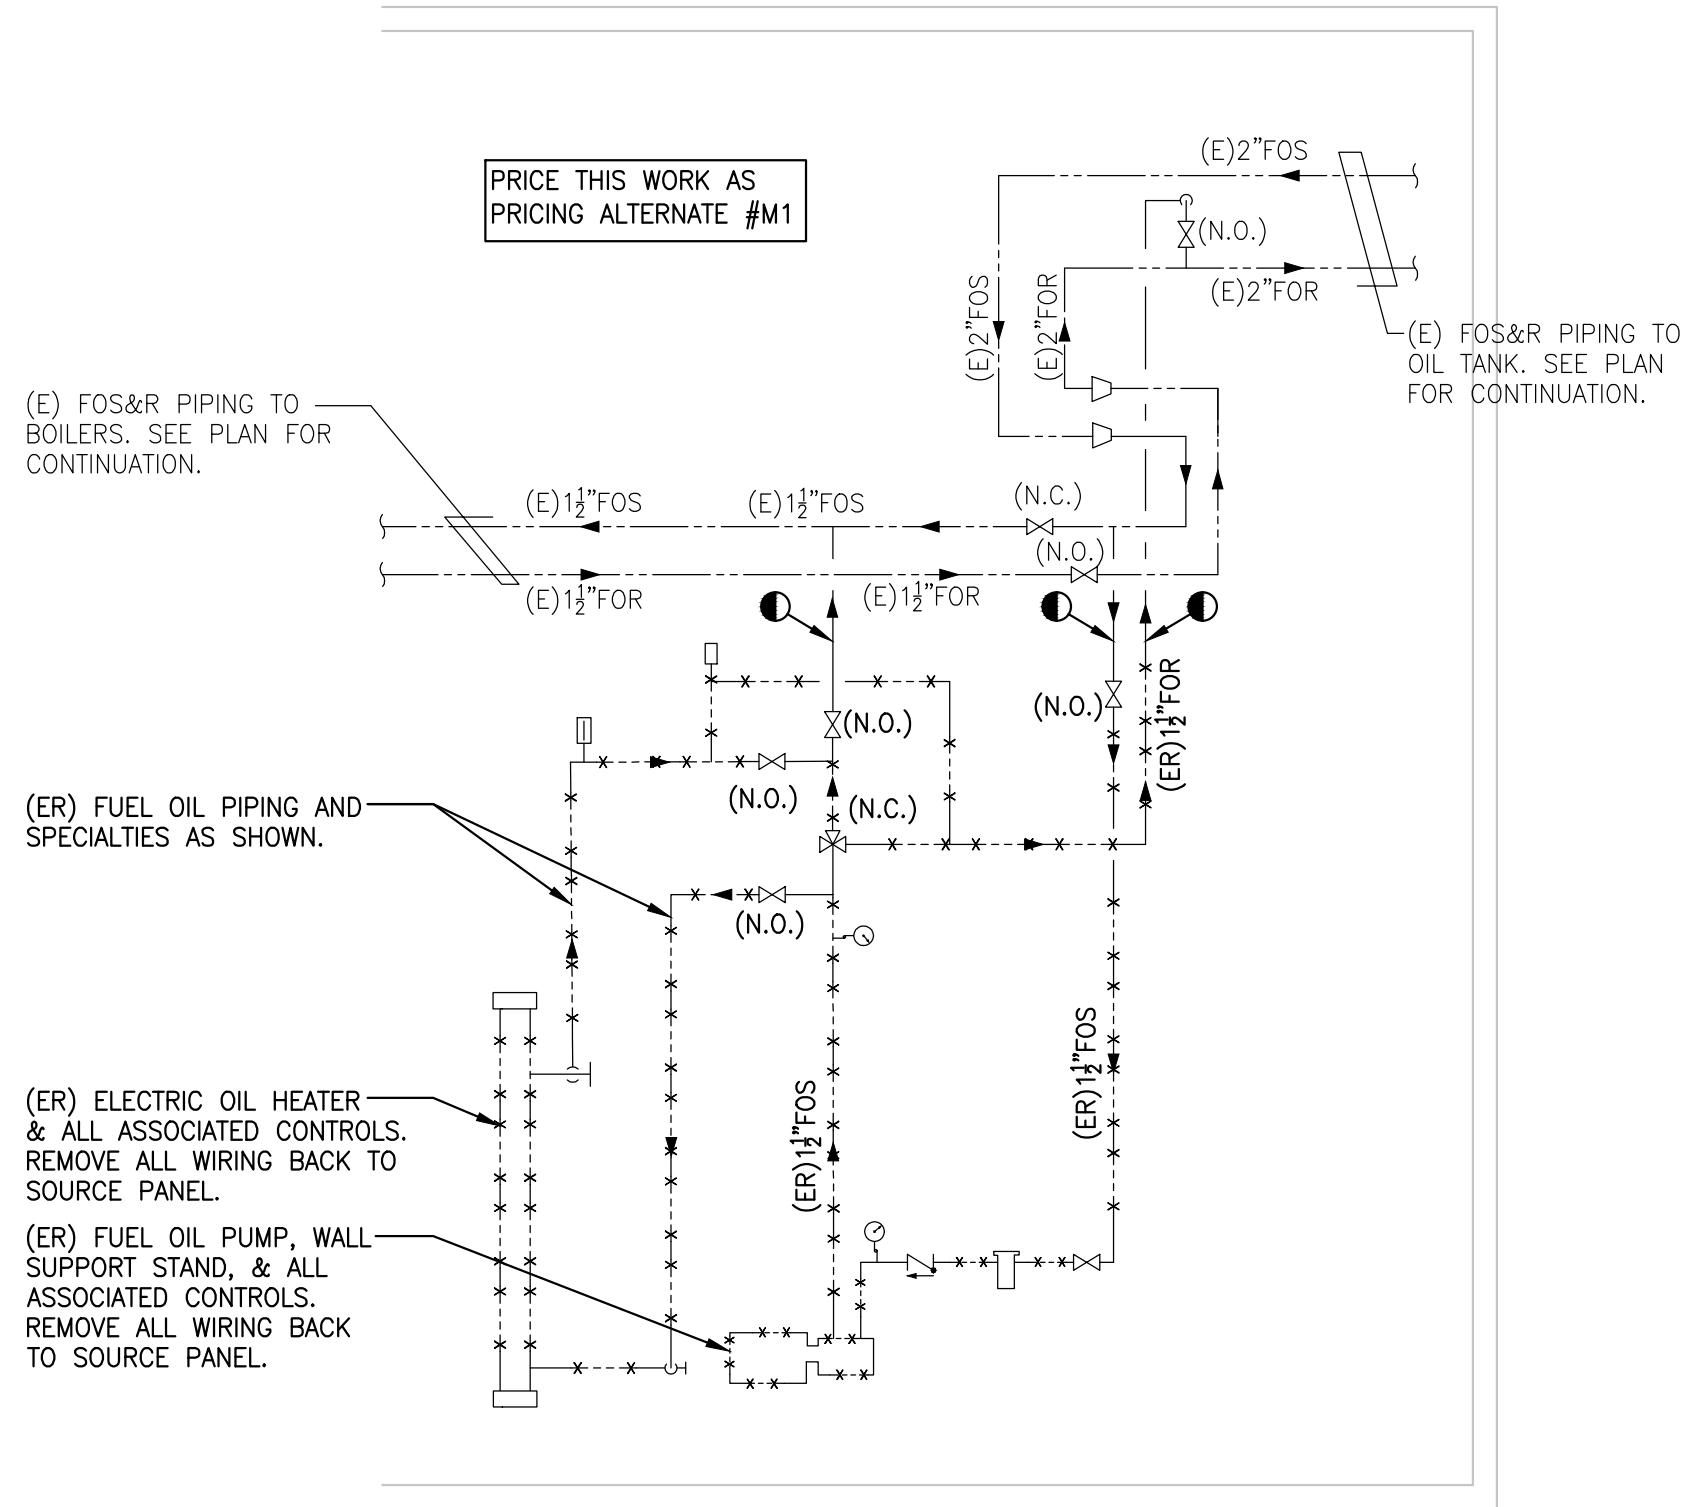P:_Projects\S13000\S130020-000\Drawings\Mech\S130020-000 - M-200.dwg




1 BOILER ROOM PARTIAL ELEVATION
PRICING ALTERNATE #M1 DEMOLITION
SCALE: N.T.S.

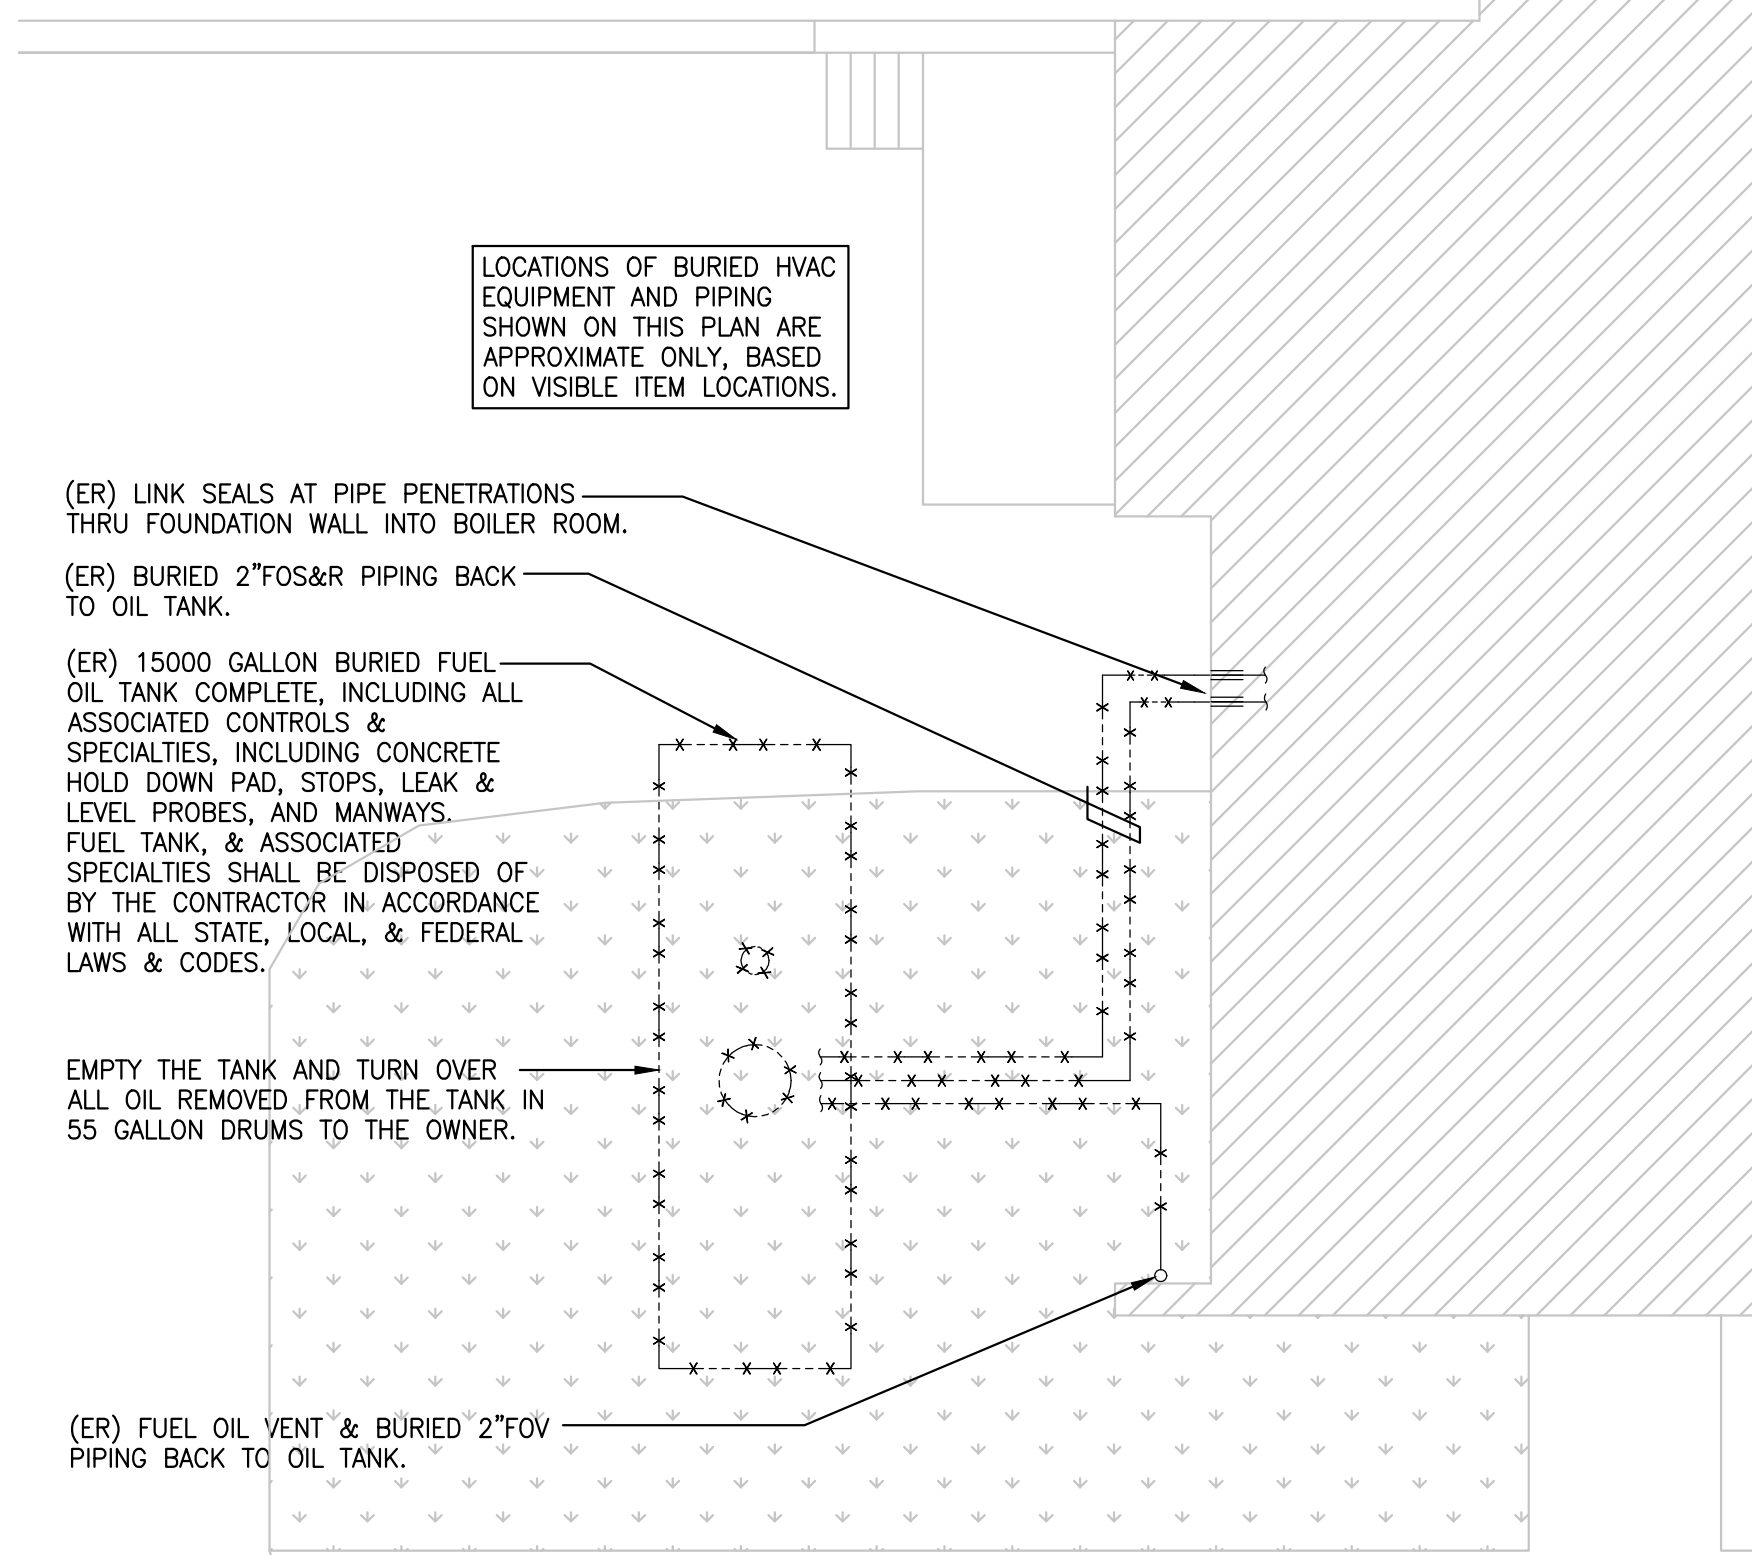- SITE WORK NOTES:**
1. CONTRACTOR SHALL HAVE ALL UNDERGROUND UTILITIES MARKED BY "CALL BEFORE YOU DIG" PRIOR TO THE START OF ANY WORK.
 2. WORK AREA TO BE MAINTAINED SO AS NOT TO PREVENT ACCESS TO LOADING DOCK.
 3. PROVIDE ALL NECESSARY SHORING OF EXCAVATION AND MAKE SAFE AT ALL TIMES.
 4. PROVIDE DEWATERING OF EXCAVATION AS NECESSARY.
 5. DURING EXISTING TANK REMOVAL, CONTRACTOR SHALL BE RESPONSIBLE FOR SOIL TESTING AND FILING WITH STATE AND LOCAL AGENCIES.
 6. SHOULD SOIL REMOVAL BE REQUIRED, COORDINATE LOCATION OF CONTAINERS WITH OWNER.
 7. PROVIDE RESTORATION OF DISTURBED AREAS TO ORIGINAL CONDITION INCLUDING PAVING AND CURBING, LANDSCAPING, GRADING, TOPSOIL, AND SEEDING OF LAWN AREAS.



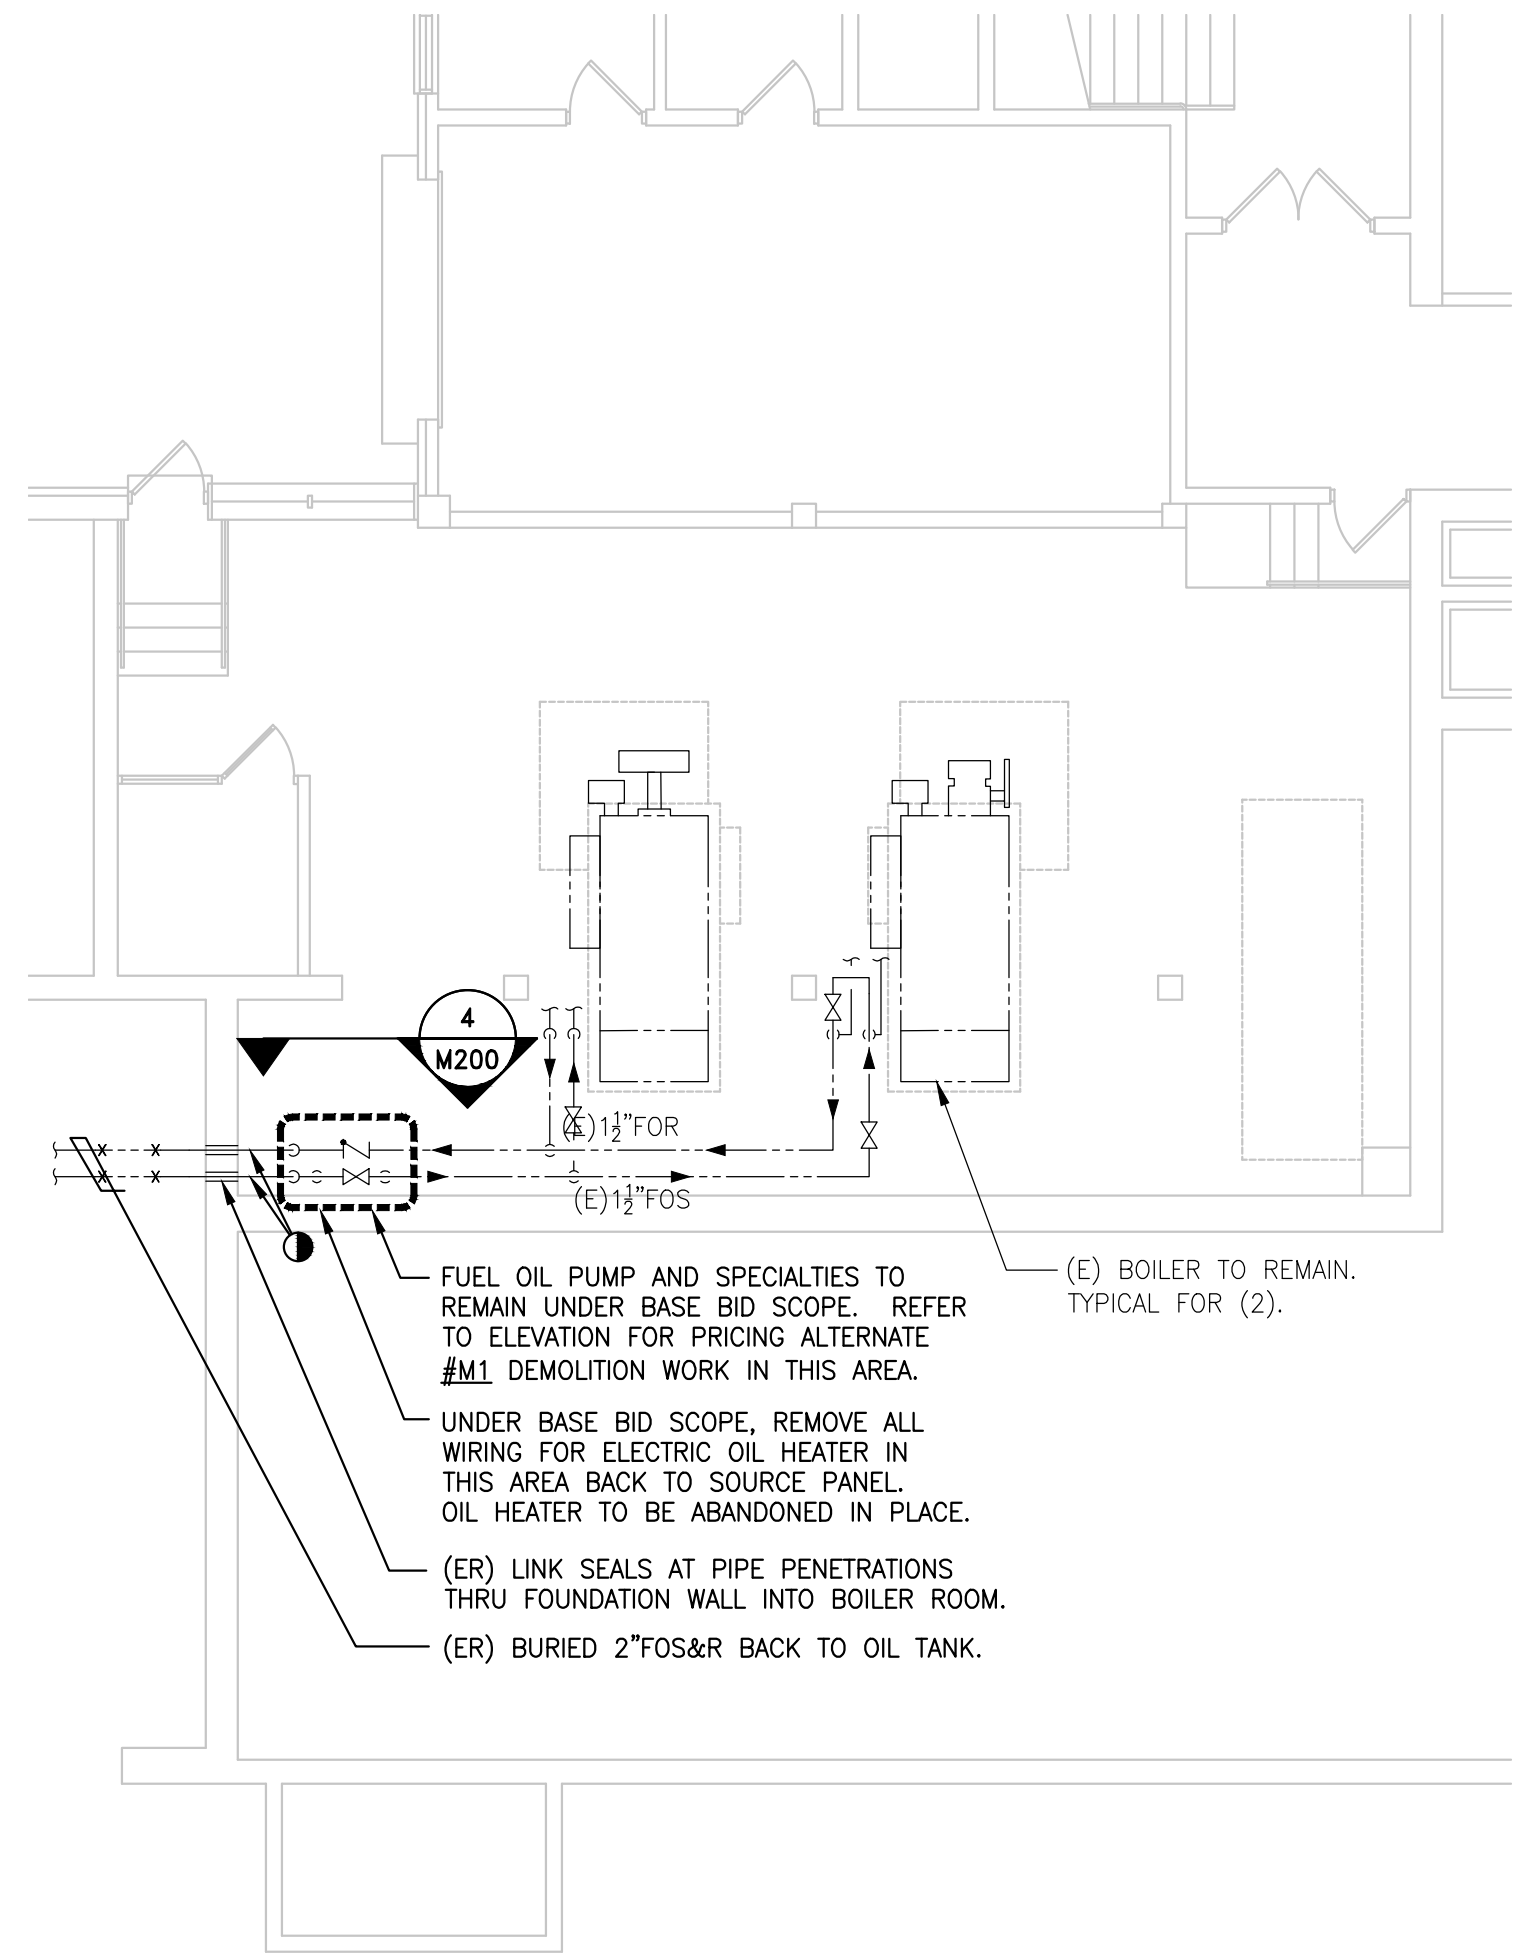2 SITE PART PLAN - DEMOLITION
SCALE: 1/8"=1'-0"



3 BOILER ROOM DEMOLITION PART PLAN
SCALE: 1/8"=1'-0"

AKF

750 East Main Street, Suite 501
Stamford, CT 06902
T: 203.323.4333 F: 203.323.2999

ARLINGTON / BOSTON / NEW YORK / MINNEAPOLIS / NEW YORK
PHILADELPHIA / PRINCETON / ROCHESTER / STAMFORD
ENGINEERING / ANALYSIS / DESIGN / BUILDING MANAGEMENT SYSTEMS / SPECIALTIES
CODE CONSULTING / CONSTRUCTION / OPERATIONAL / FINANCIAL / SUSTAINABILITY
HUMAN RESOURCES / IT / AV / SECURITY / DESIGN / SPECIALTIES
www.akfusa.com



ANTINOZZI ASSOCIATES
ARCHITECTURE & INTERIORS

OWNER

Trumbull Public Schools
6254 Main Street
Trumbull, CT 06611

4	04/08/2014	ISSUED FOR BID
3	03/07/2014	ISSUED FOR BID
2	09/13/2013	ISSUED FOR BID
1	07/16/2013	ISSUED FOR REVIEW
No.	Date	Description

ISSUE

PROJECT

Fuel Oil Tank Replacement
Middlebrook Elementary School
220 Middlebrooks Ave.
Trumbull, CT 06611

DRAWING TITLE

MECHANICAL
DEMOLITION PLANS

Drawn By

JR

Checked By

JM

Date

07/16/2013

Scale

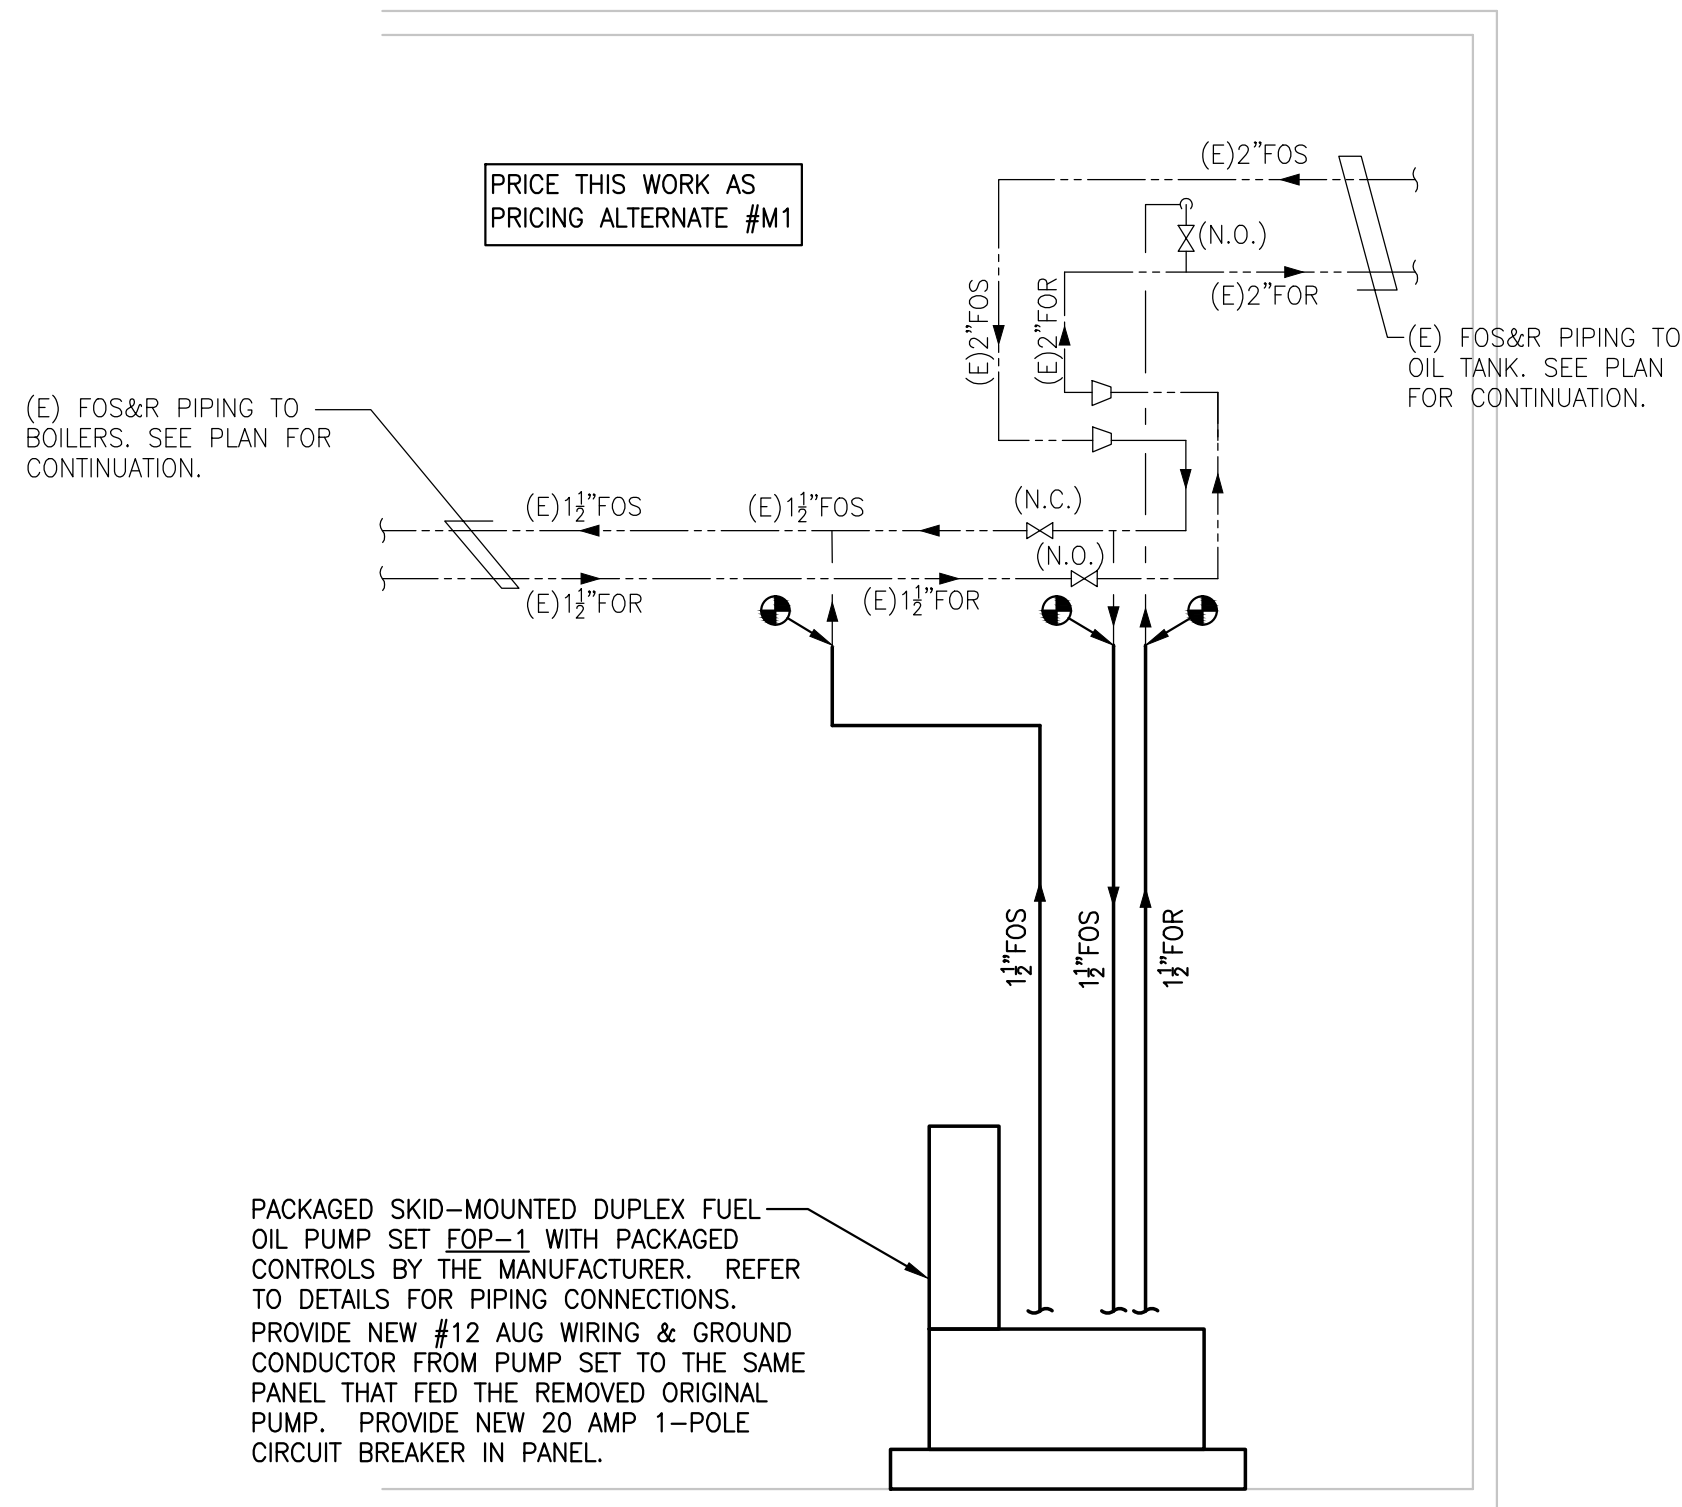
AS NOTED

Project No.


S130020-000

Drawing No.


M-200



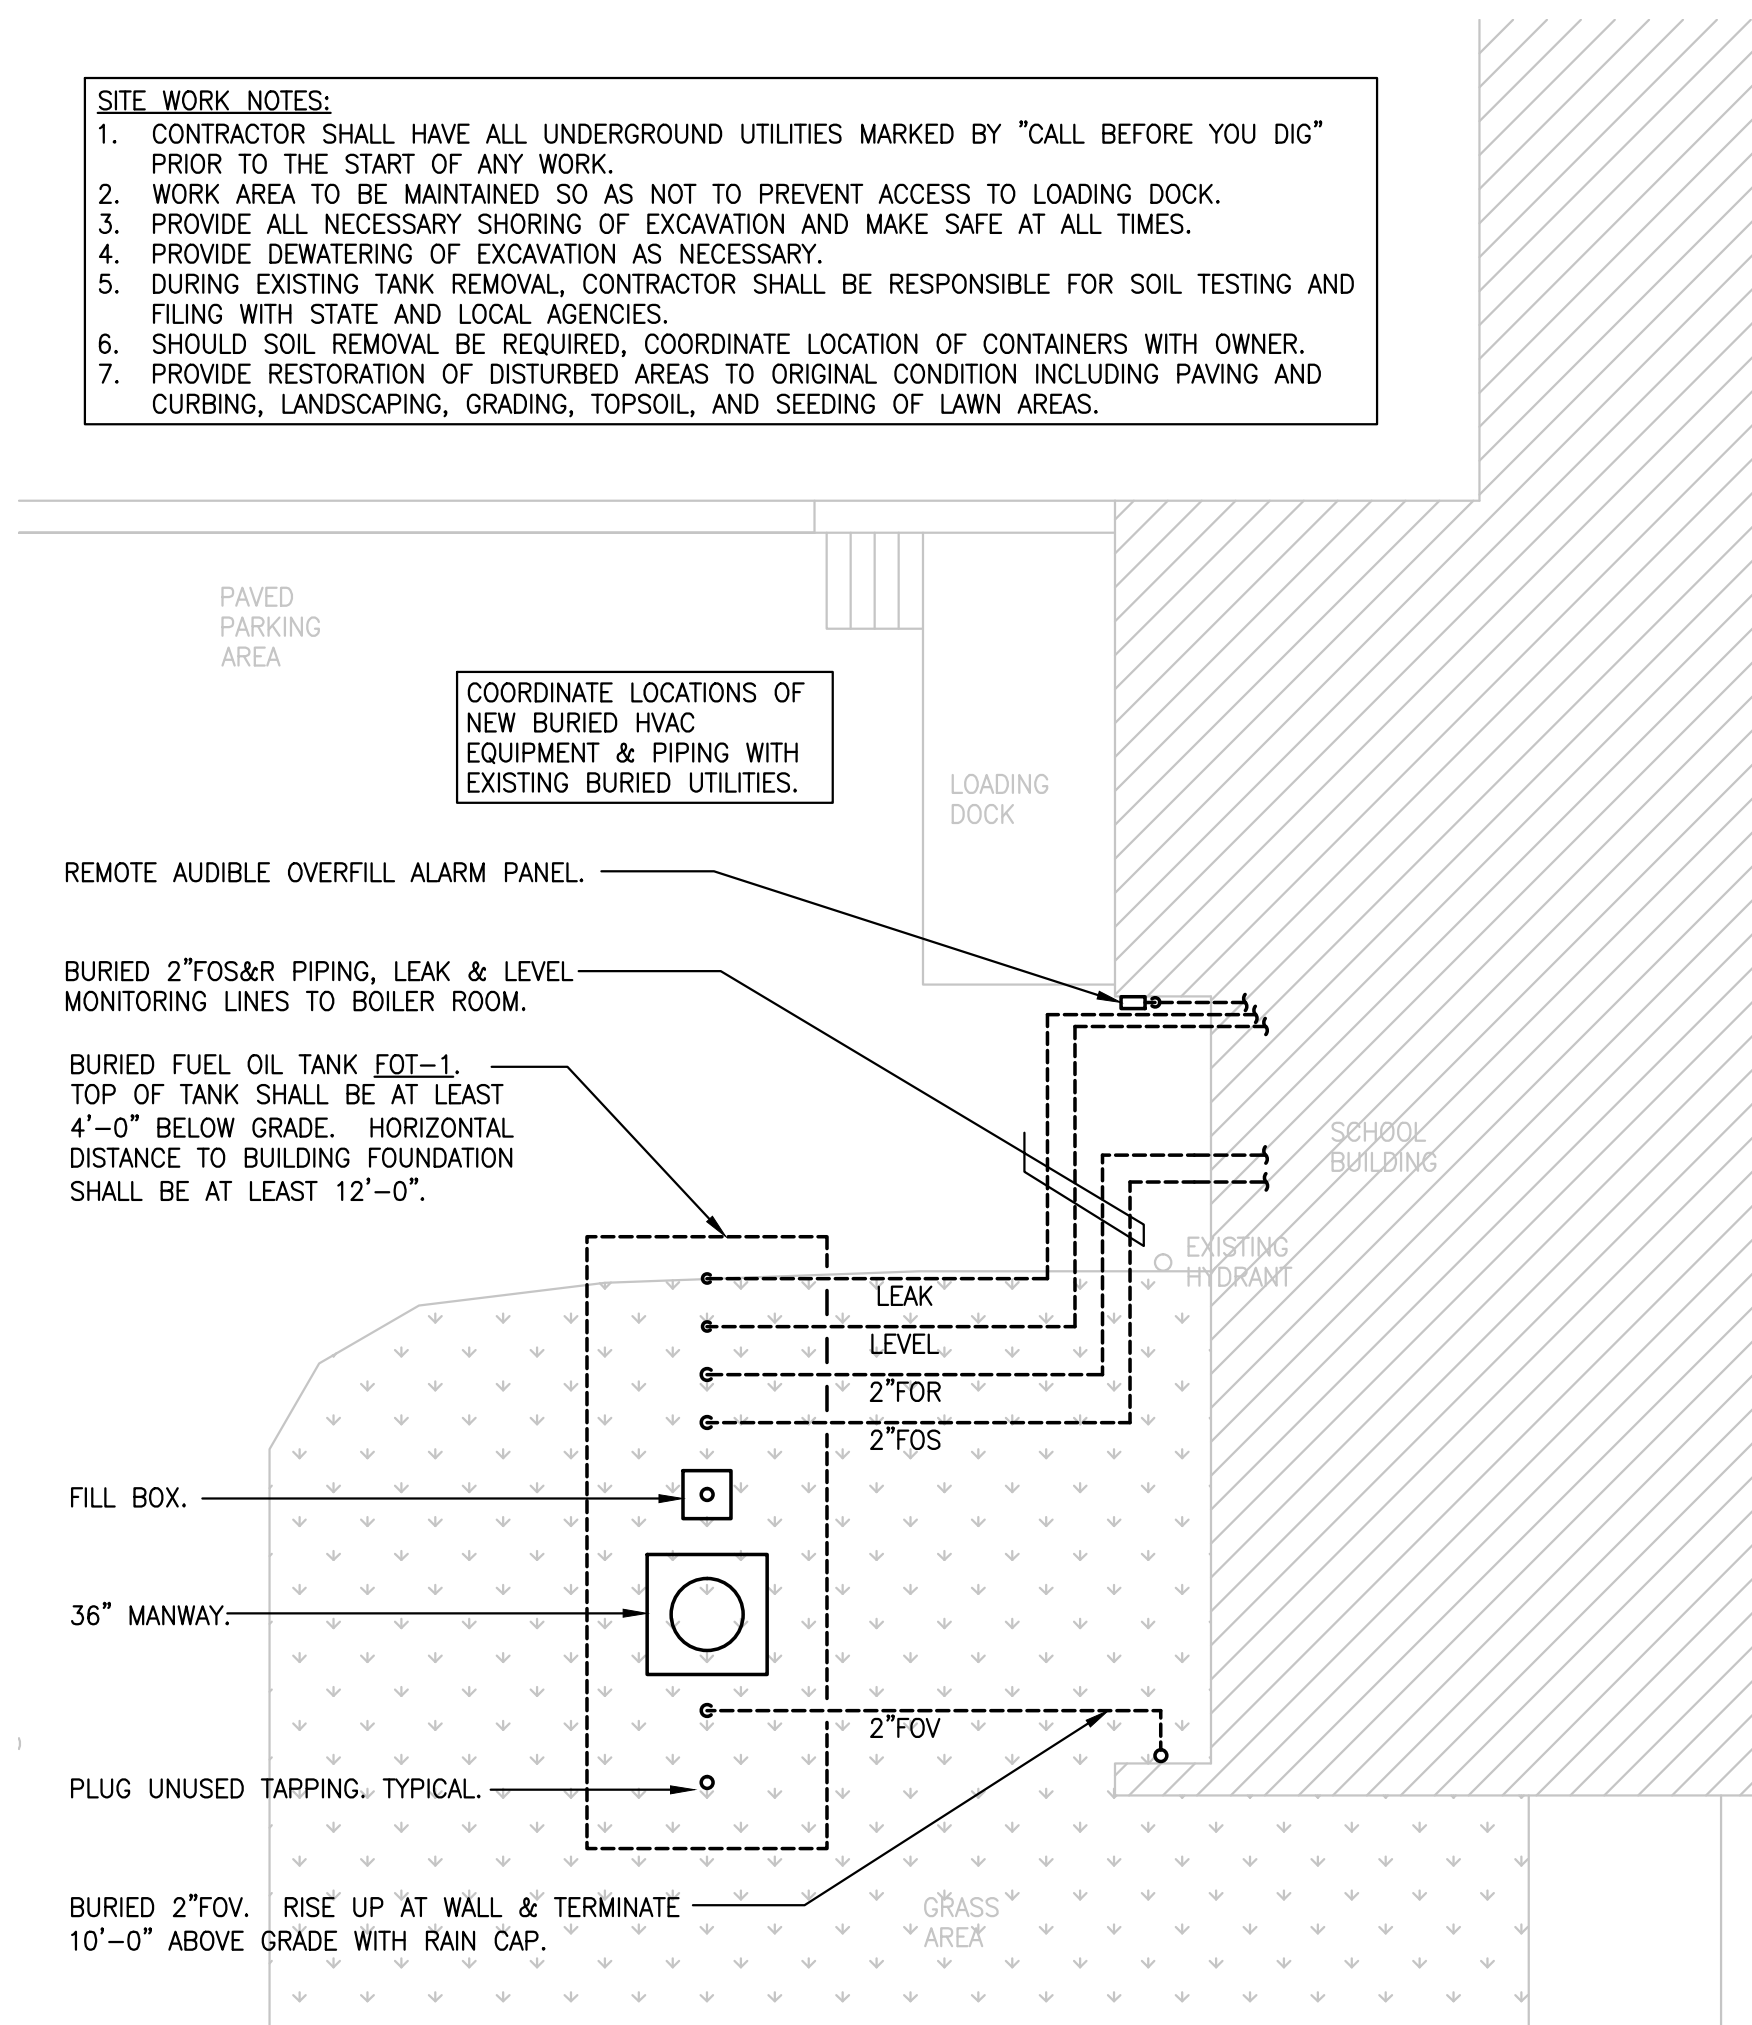
1 BOILER ROOM PARTIAL ELEVATION PRICING ALTERNATE #M1 NEW WORK
SCALE: N.T.S.



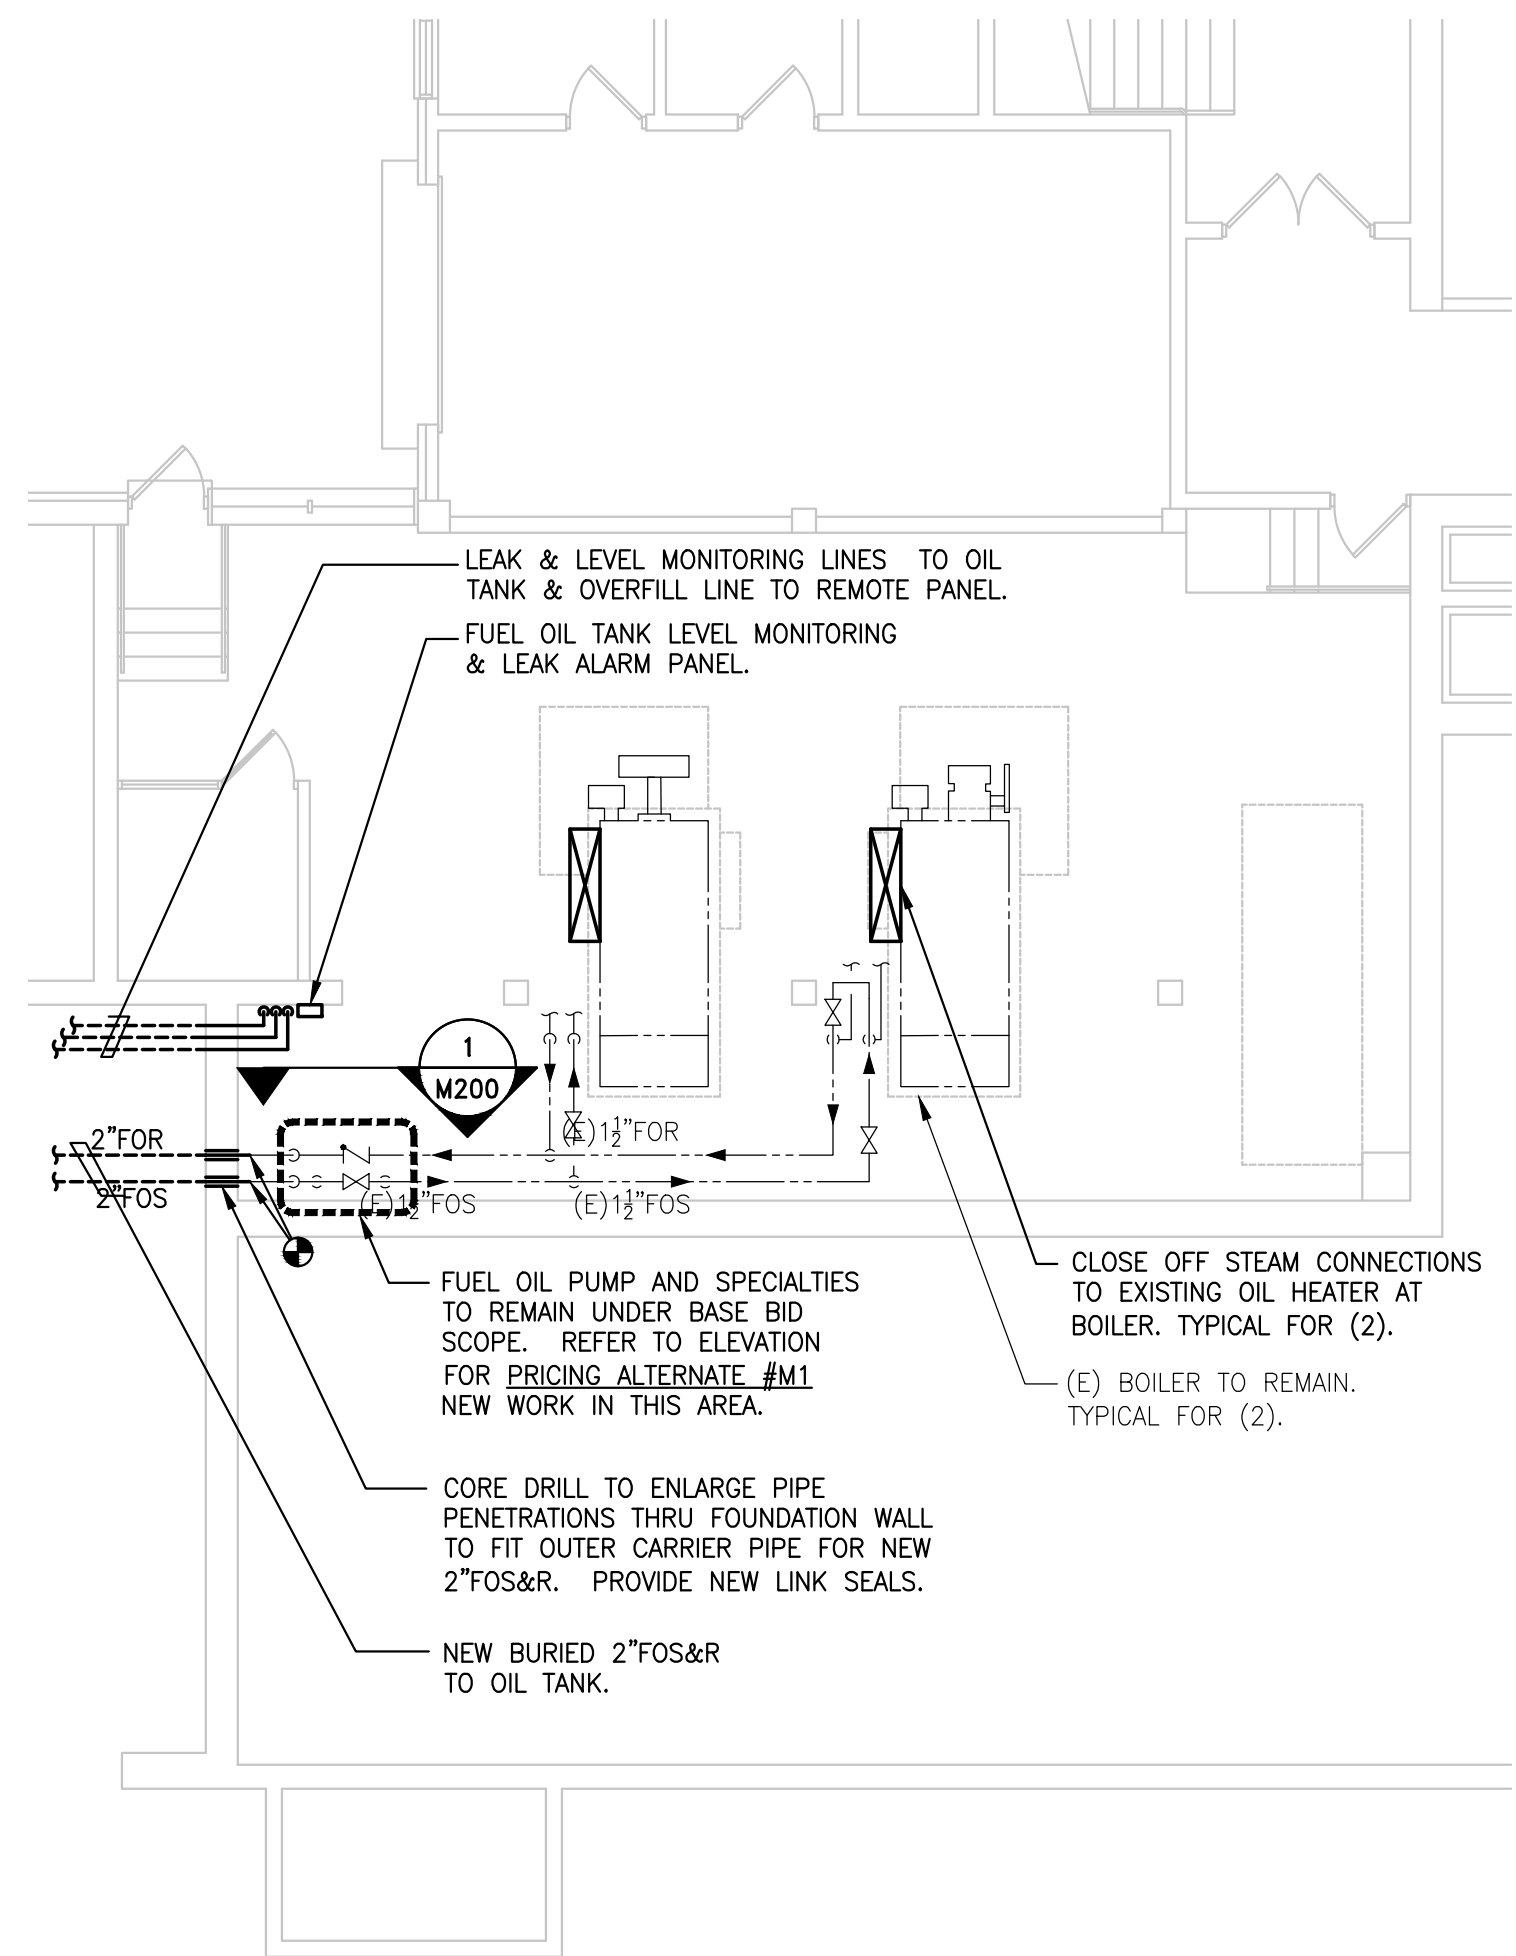2 SITE PART PLAN - NEW WORK
SCALE: 1/8"=1'-0"



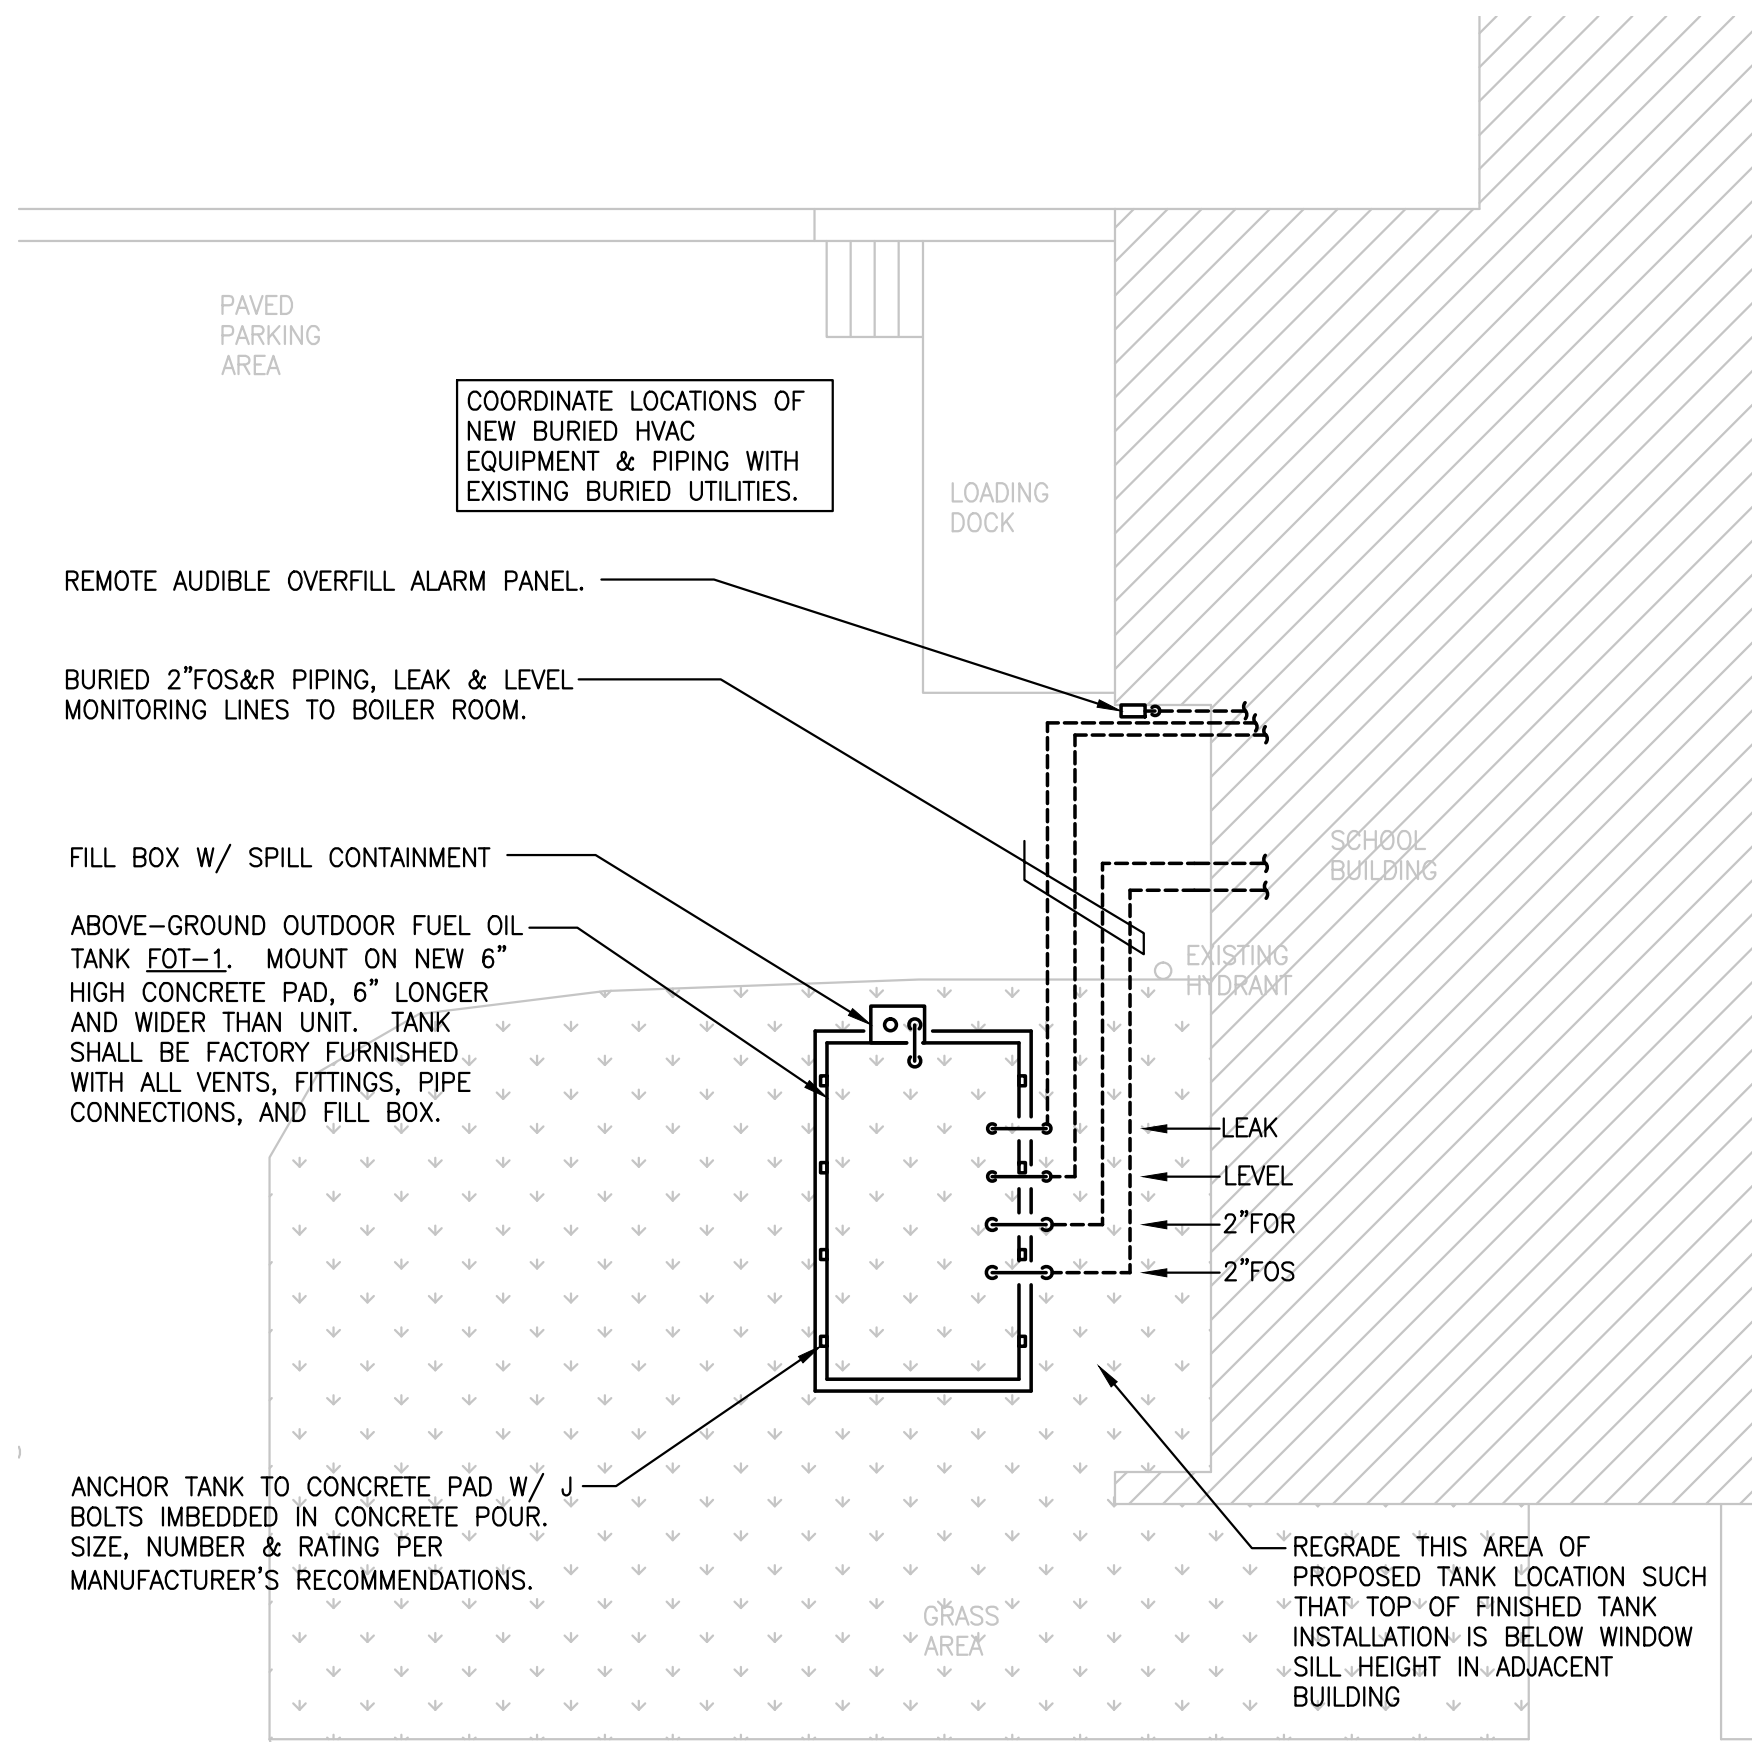3 BOILER ROOM NEW WORK PART PLAN
SCALE: 1/8"=1'-0"



4 SITE PART PLAN - NEW WORK PRICING ALTERNATE #M3
SCALE: 1/8"=1'-0"



ANTINOZZI ASSOCIATES
ARCHITECTURE & INTERIORS


OWNER
Trumbull Public Schools
6254 Main Street
Trumbull, CT 06611

4	04/08/2014	ISSUED FOR BID
3	03/07/2014	ISSUED FOR BID
2	09/13/2013	ISSUED FOR BID
1	07/16/2013	ISSUED FOR REVIEW
No.	Date	Description


PROJECT
Fuel Oil Tank Replacement
Middlebrook Elementary School
220 Middlebrooks Ave.
Trumbull, CT 06611

DRAWING TITLE
MECHANICAL
NEW WORK PLANS


Drawn By	JR	Drawing No.	M-300
Checked By	JM		
Date	07/16/2013		
Scale	AS NOTED		
Project No.	130020-000		

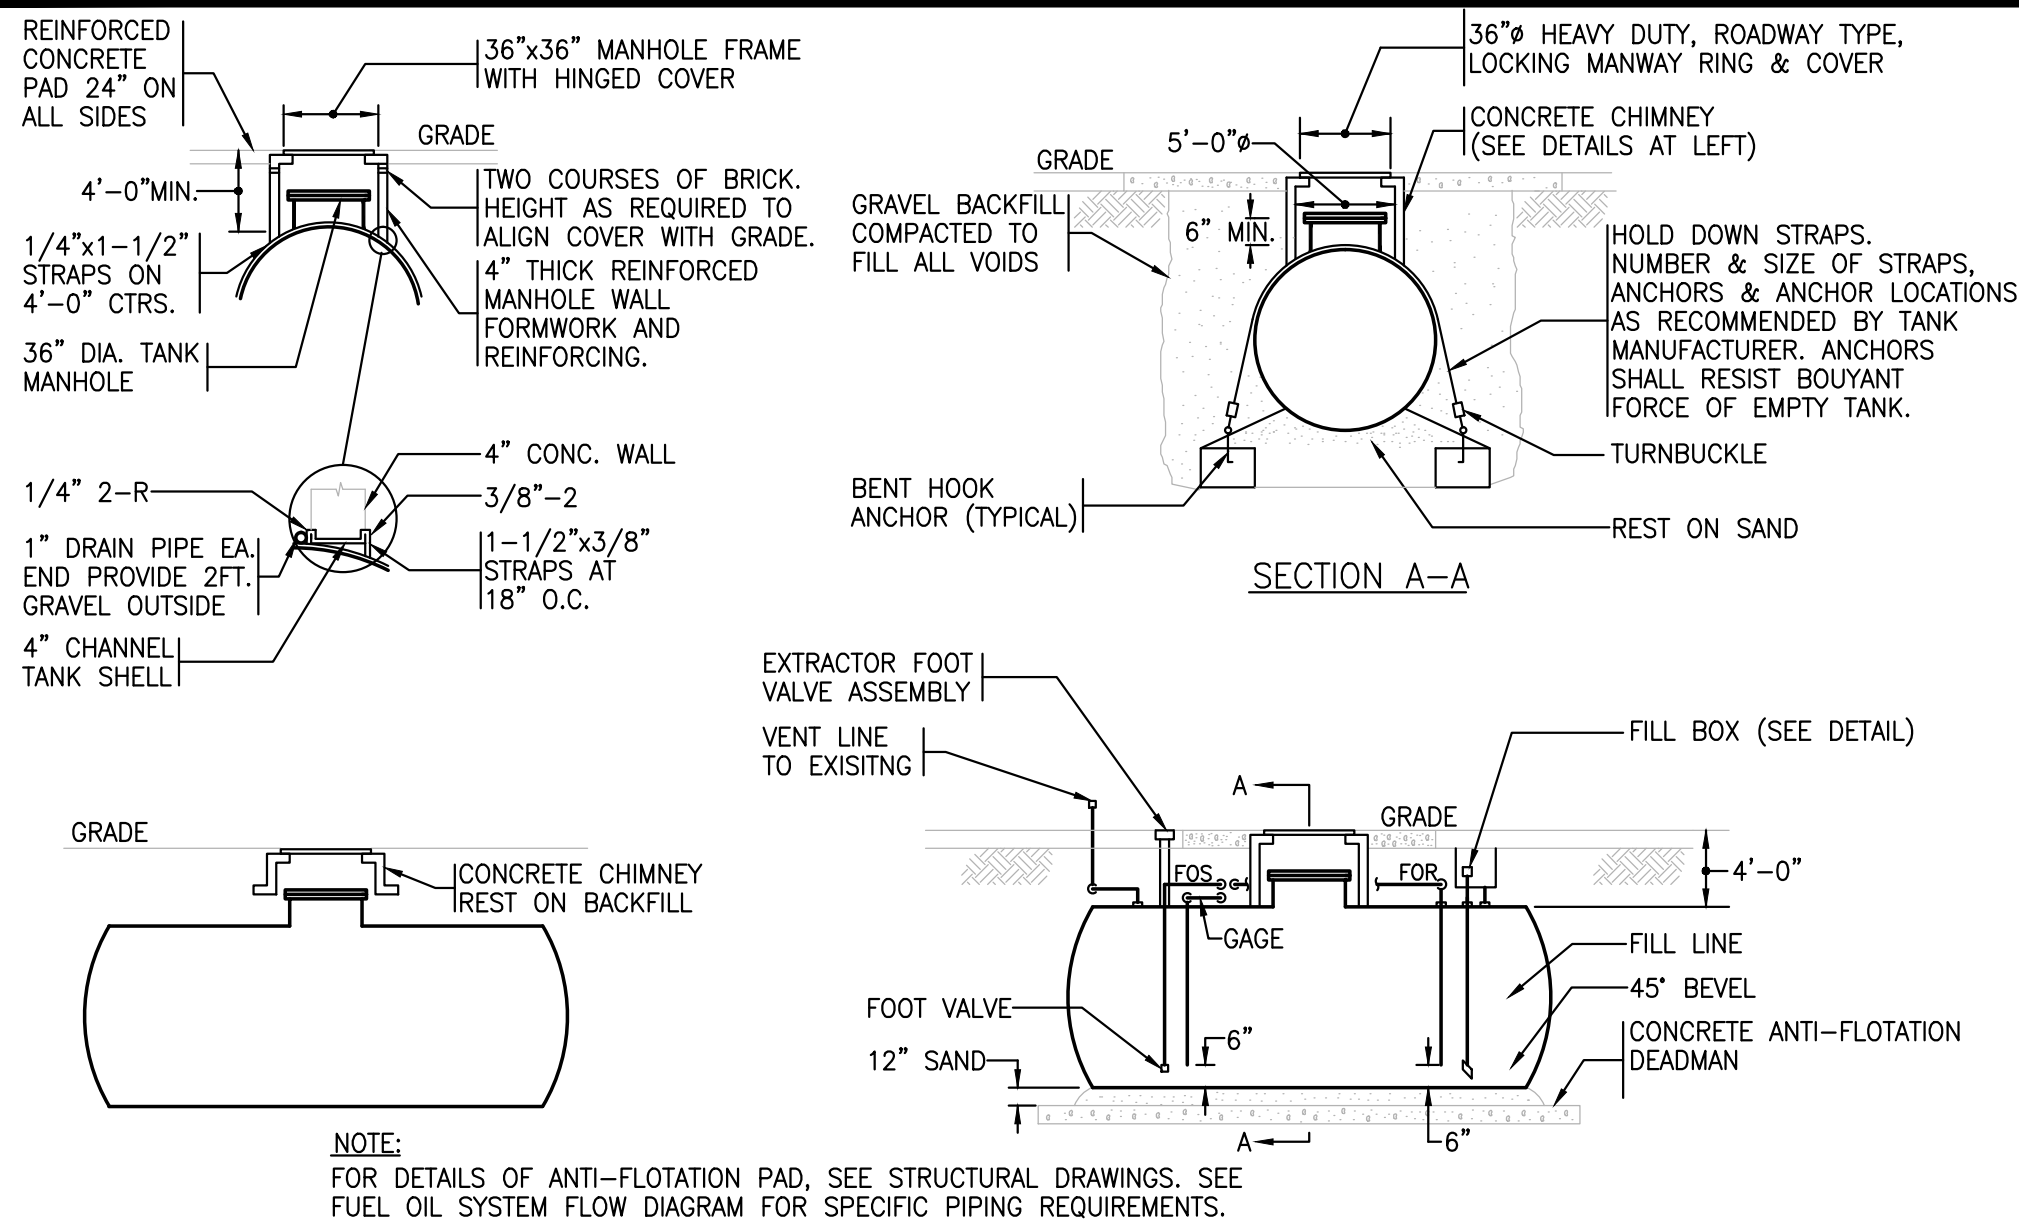

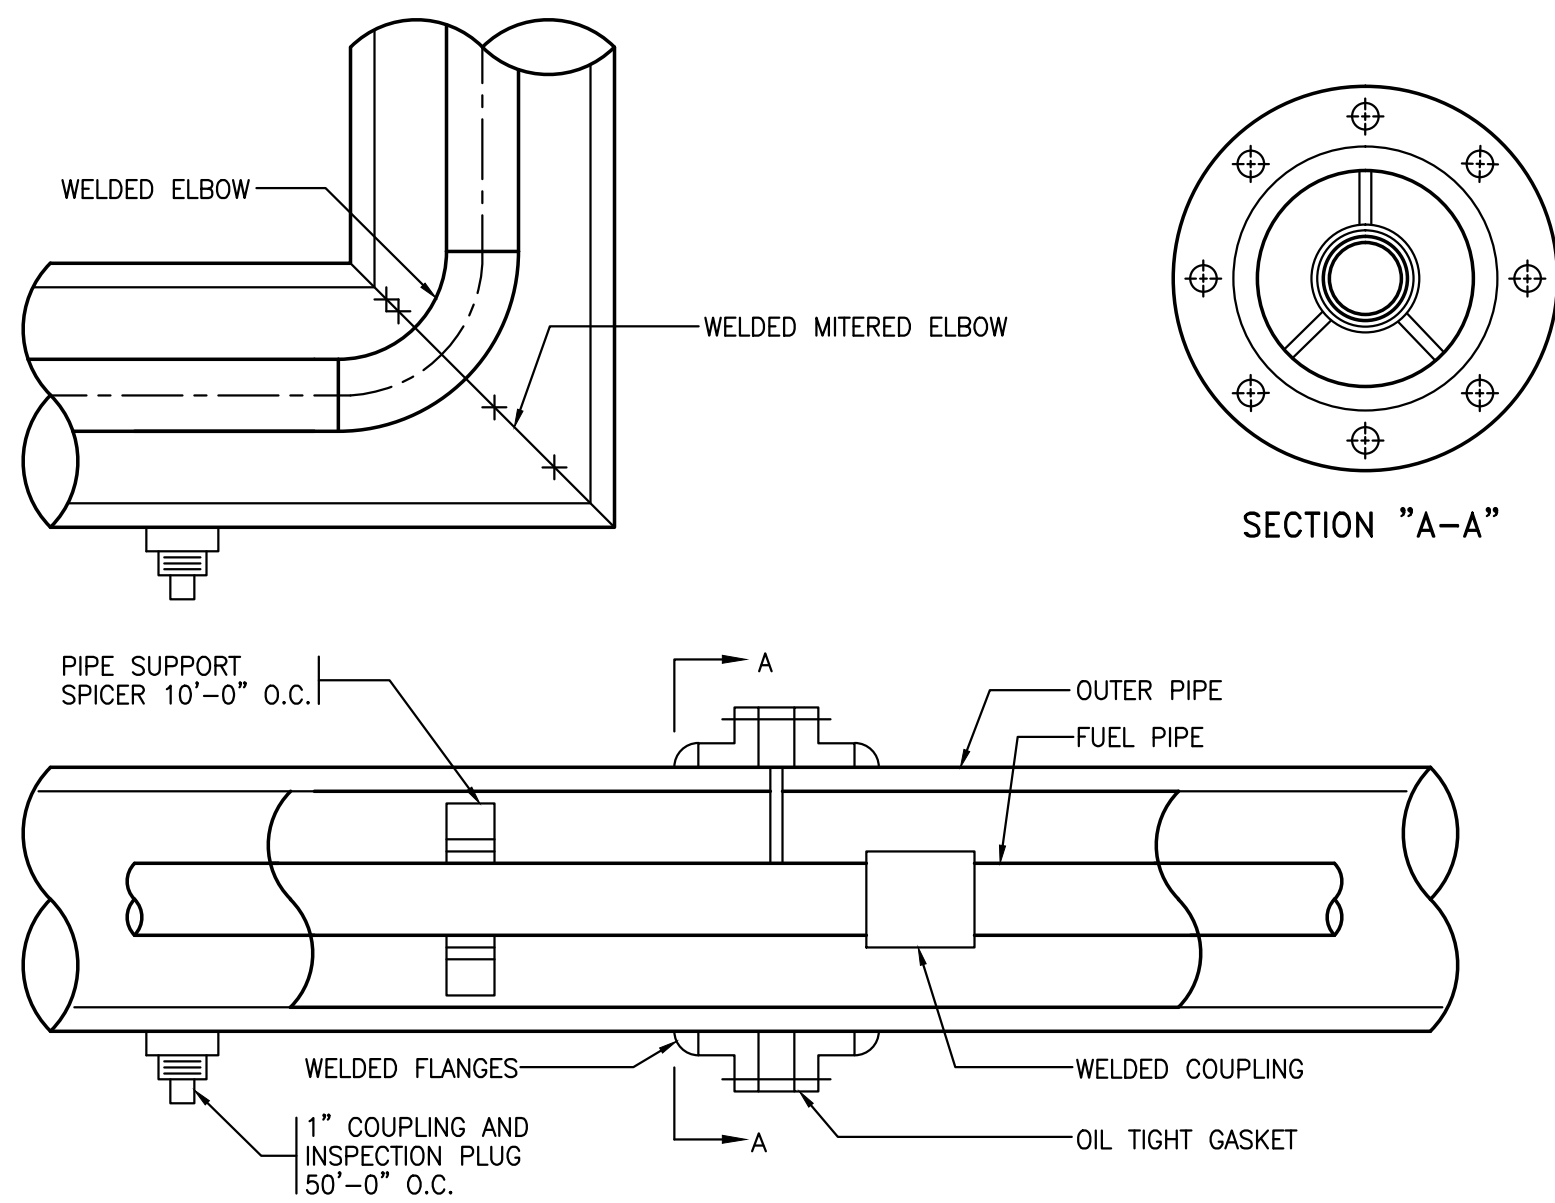1 UNDERGROUND STEEL FUEL OIL STORAGE TANK
M300



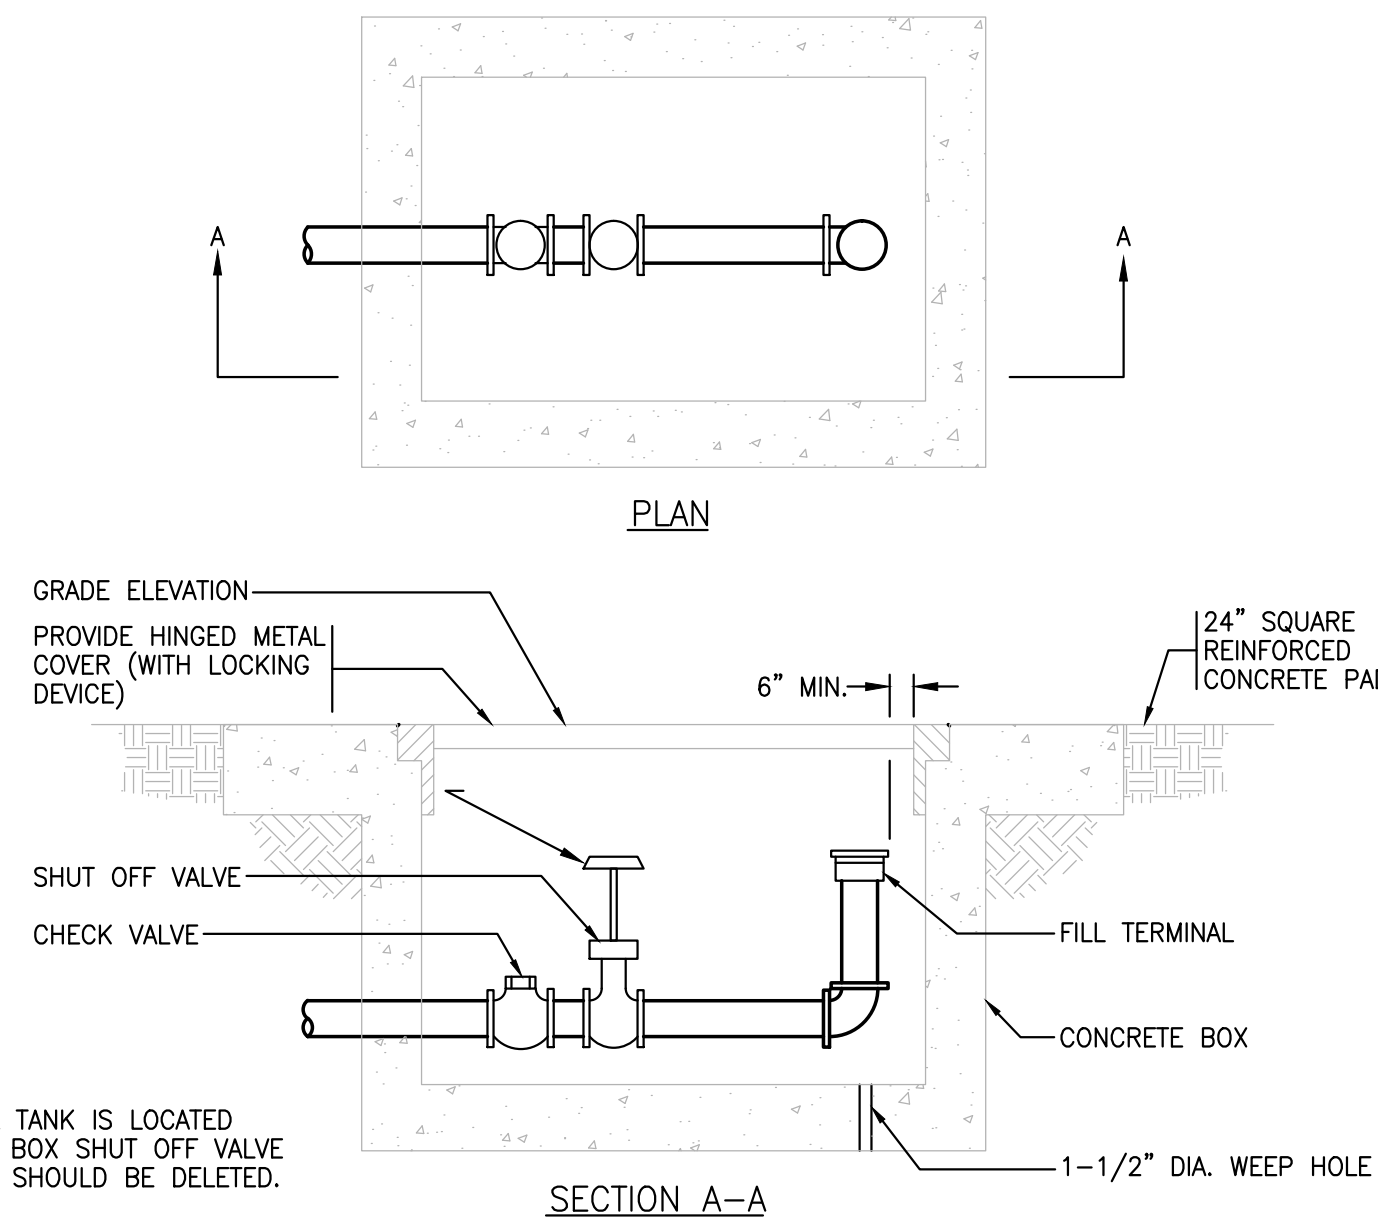2 FUEL PIPE DOUBLE WALL CONSTRUCTION
M300



4 FUEL FILL BOX
M300

DUPLIX FUEL OIL PUMP SCHEDULE											
UNIT No.	LOCATION	SERVICE	MAX. OIL TEMP. (°F)	GPH (EACH)	DISC. PRESSURE (PSIG)	RPM	MOTOR HP (EACH)	ELECTRICAL DATA			REMARKS
FOP-1 (PRICING ALTERNATE #1)	BOILER RM	NO.2 OIL	100	222	25	1750	1/4	VOLTS	PHASE	HZ	SEE NOTES BELOW
								120	1	60	


NOTES:

1. INCLUDE THE FOLLOWING COMPONENTS: RELIEF AND CHECK VALVES ON EACH PUMP, FUEL OIL STRAINER, SUCTION AND STRAINER ISOLATION BALL VALVES, SET MOUNTED CONTROL PANEL WITH MOTOR CONTACTORS, H-O-A SWITCH, PUMP SELECTOR SWITCH, AND INDICATOR LIGHTS.


BURIED DOUBLE-WALL FUEL OIL STORAGE TANK SCHEDULE											
UNIT No.	LOCATION	TYPE	MATERIAL		CAPACITY (GAL.)	DIA. (FT.-IN.)	LENGTH (FT.-IN.)	MANHOLES DIAMETER (IN.)	MAX. OIL TEMP. (°F)	TANK	
FOT-1 (BASE BID SCOPE)	RE: PLAN	BURIED	POLYMER	STEEL	15,000	10'-0"	25'-6"	36	100	HIGHLAND TANK	TITAN
FOT-1 (PRICING ALTERNATE #2)	RE: PLAN	BURIED	POLYMER	STEEL	6,000	8'-0"	16'-0"	36	100	HIGHLAND TANK	TITAN

OUTDOOR ABOVE-GROUND DOUBLE-WALL FIRE-RATED FUEL OIL STORAGE TANK SCHEDULE

UNIT No.	LOCATION	TYPE	MATERIAL			CAPACITY (GAL.)	LENGTH (FT.-IN.)	WIDTH (FT.-IN.)	HEIGHT (FT.-IN.)	MANHOLES DIAMETER (IN.)	MAX. OIL TEMP. (°F)	TANK		REMARKS
			OUTER WALL	INTERSTITIAL SPACE	INNER WALL							MANUF.	MODEL #	
FOT-1 (PRICING ALTERNATE #3)	RE: PLAN	OUTDOOR	3/16" STEEL	4" LW CONCRETE	1/4" STEEL	3,000	14'-0"	7'-11"	4'-11"	36	100	CONTAINMENT SOLUTIONS	HOOVER VAULT	UL-2058, UL-142, 2-HR FIRE RATED, FACTORY-MOUNTED REMOTE FILL BOX

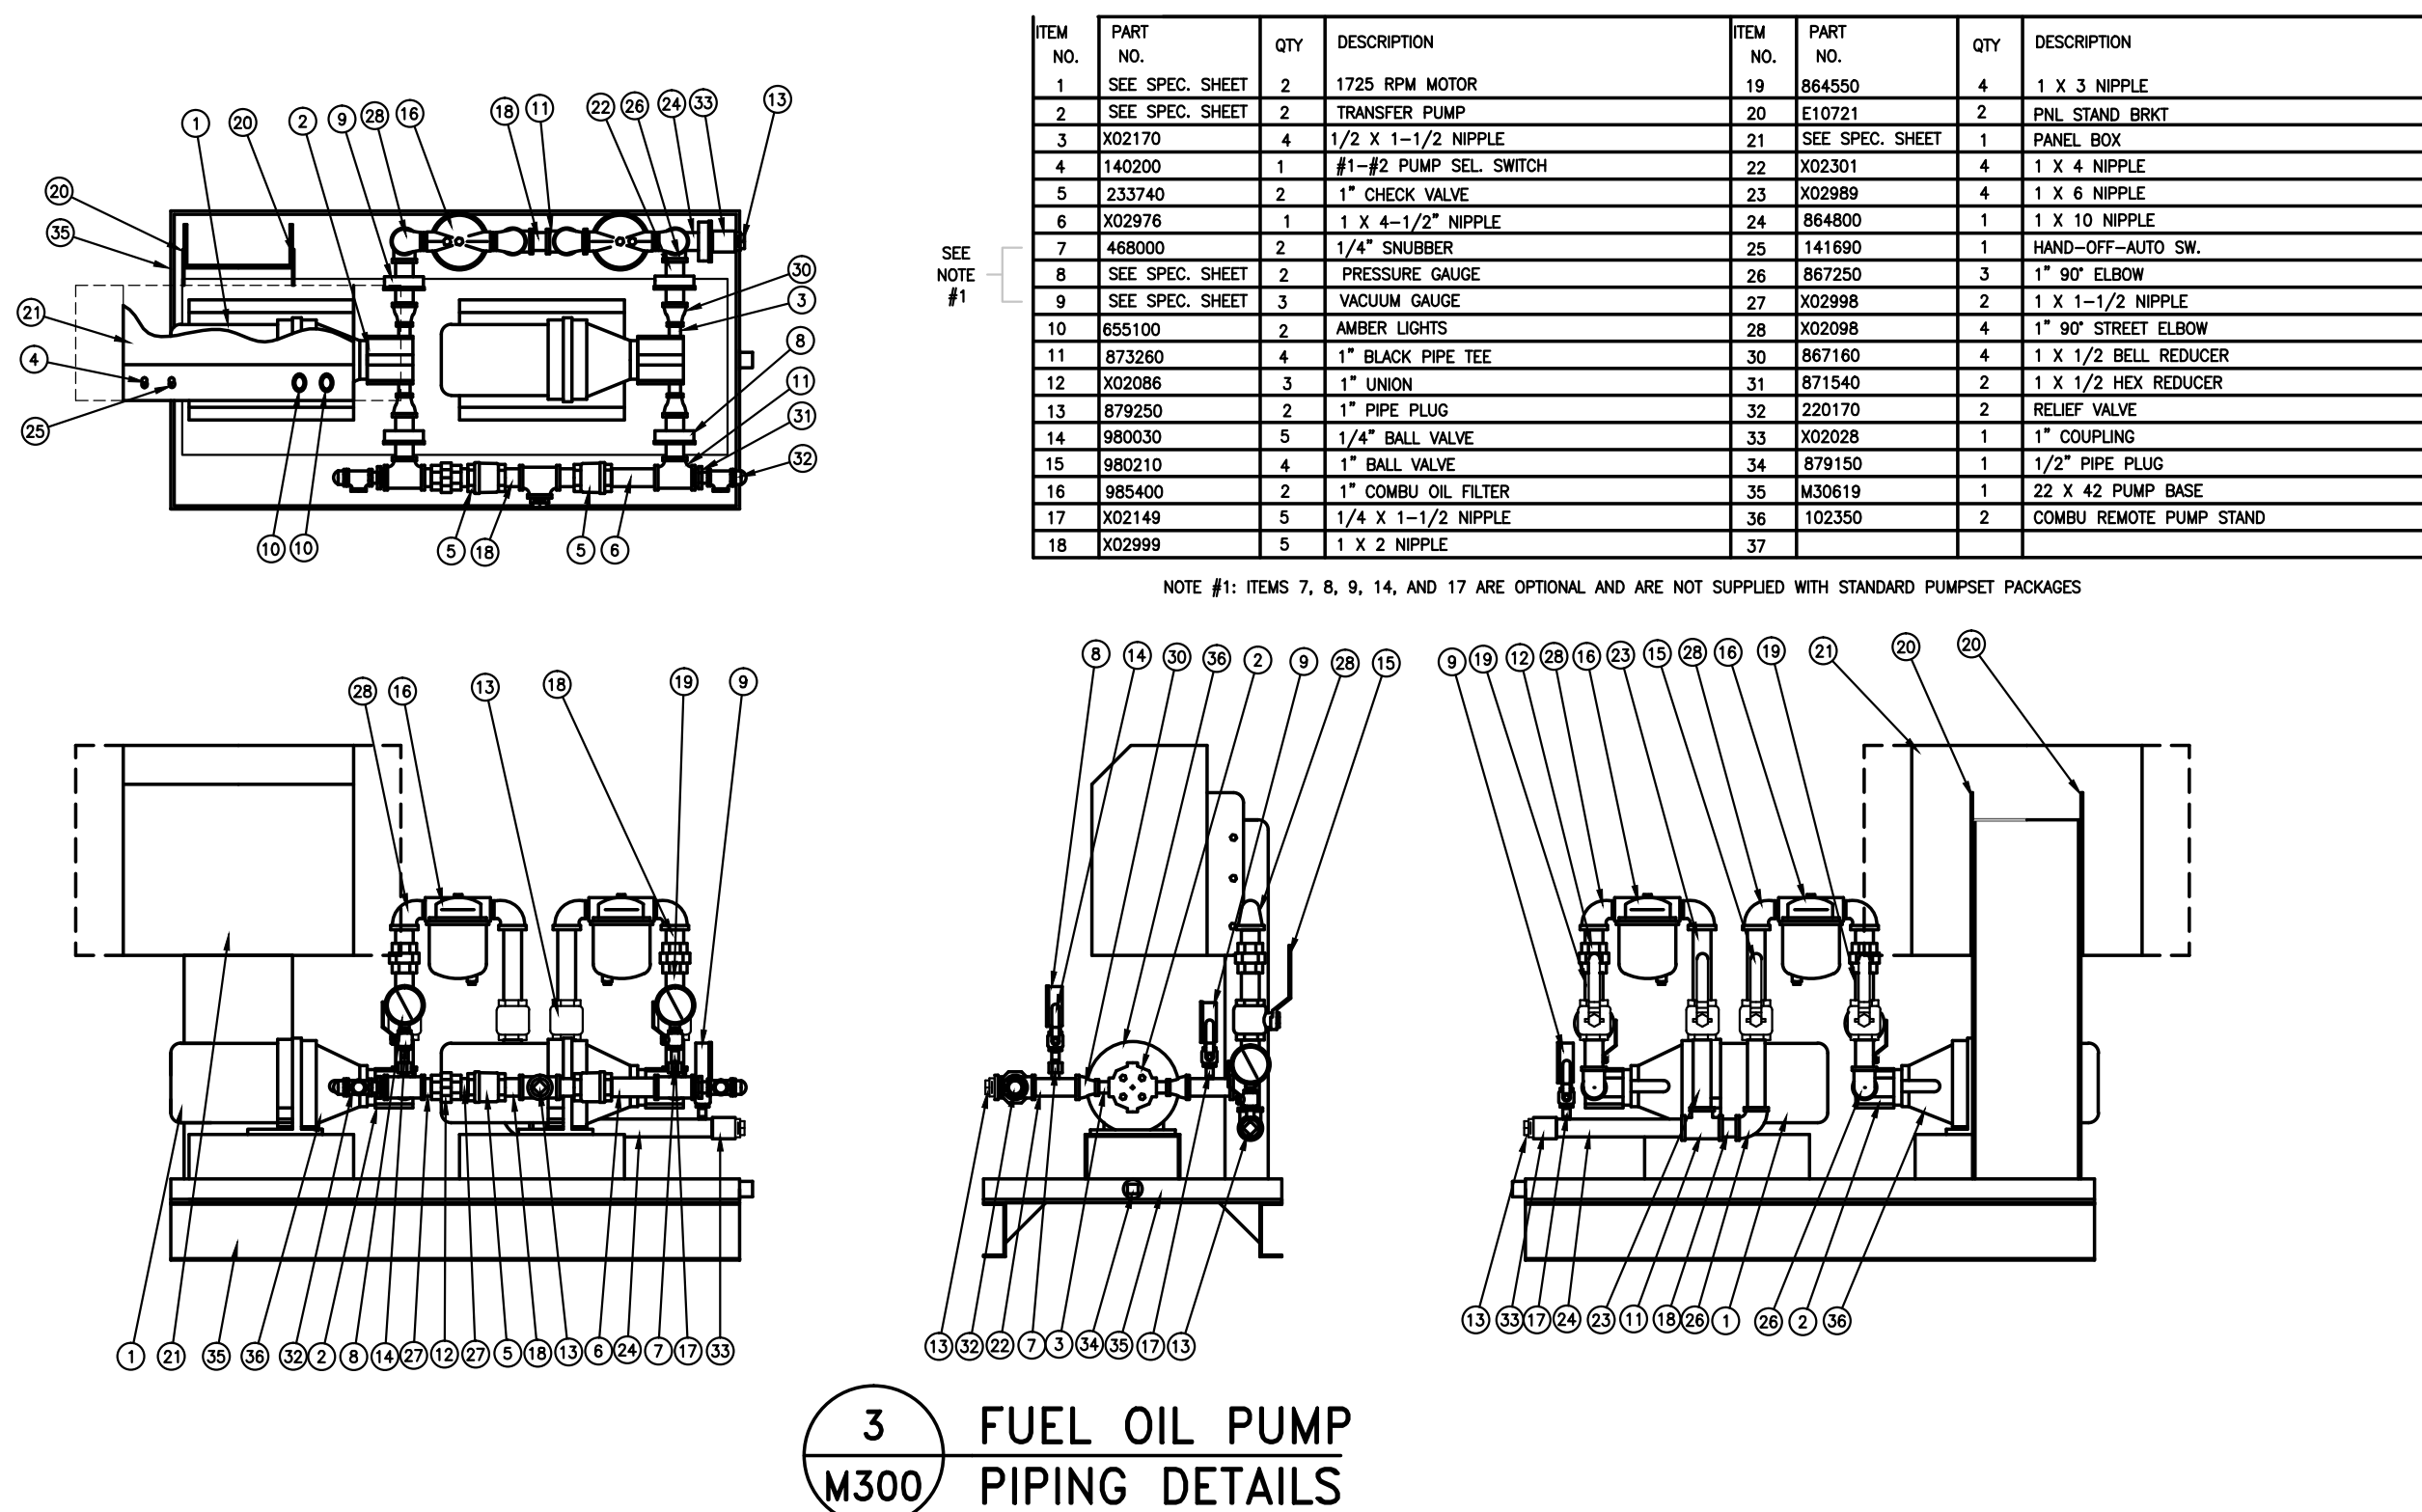

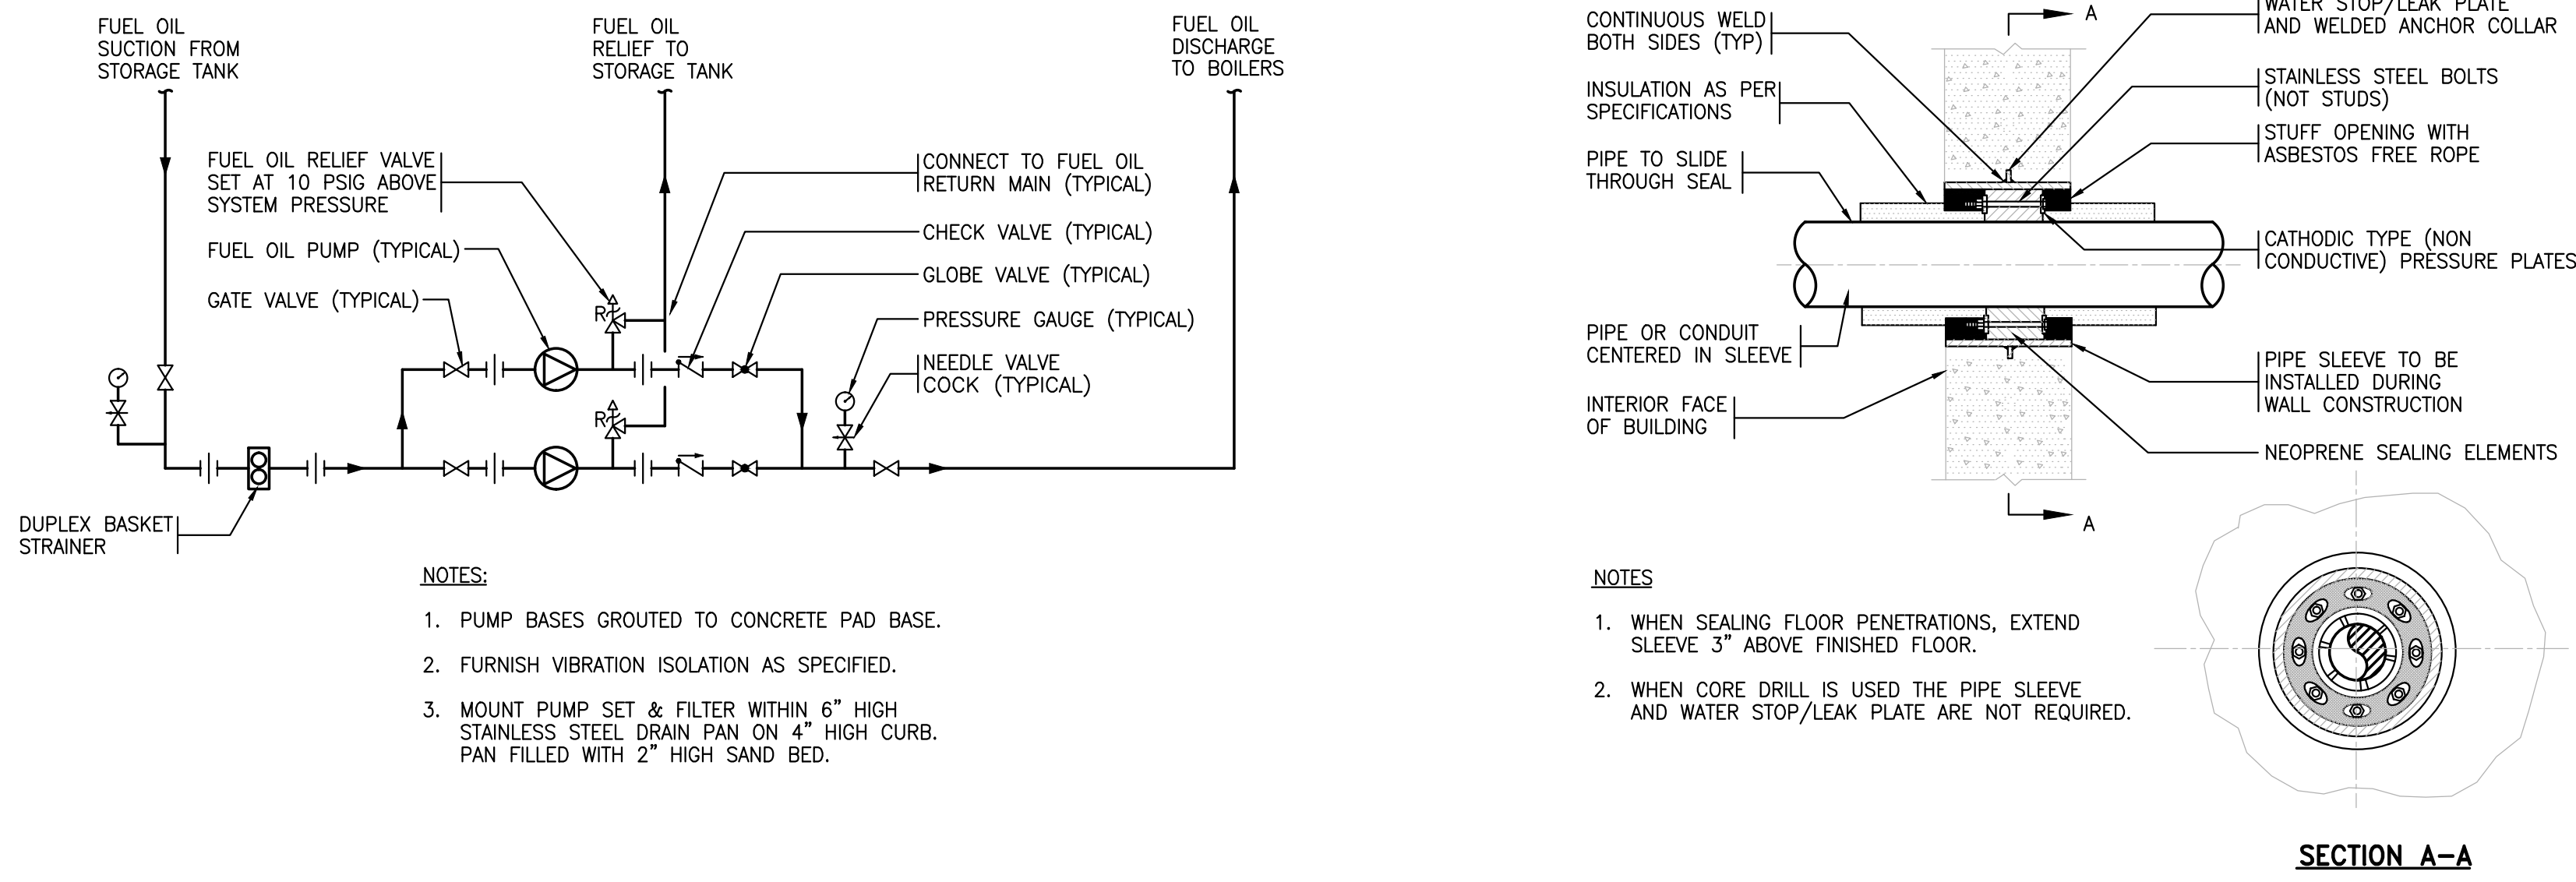NOTE #1: ITEMS 7, 8, 9, 14, AND 17 ARE OPTIONAL AND ARE NOT SUPPLIED WITH STANDARD PUMPSET PACKAGES



NOTES:

1. PUMP BASES GROUTED TO CONCRETE PAD BASE.
2. FURNISH VIBRATION ISOLATION AS SPECIFIED.
3. MOUNT PUMP SET & FILTER WITHIN 6" HIGH STAINLESS STEEL DRAIN PAN ON 4" HIGH CURB. PAN FILLED WITH 2" HIGH SAND BED.

NOTES:

1. WHEN SEALING FLOOR PENETRATIONS, EXTEND SLEEVE 3" ABOVE FINISHED FLOOR.
2. WHEN CORE DRILL IS USED THE PIPE SLEEVE AND WATER STOP/LEAK PLATE ARE NOT REQUIRED.

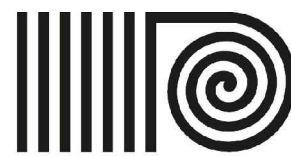
SECTION A-A

6 MOLDED RUBBER BOLTED SEAL ASSEMBLY
M300

AKF

750 East Main Street, Suite 501
Stamford, CT 06902
T: 203.323.4333 F: 203.323.2999

BRISTOL / BOSTON / CHICAGO / CINCINNATI / CLEVELAND / DALLAS / DENVER / DETROIT / HOUSTON / KANSAS CITY / LOS ANGELES / MINNEAPOLIS / NEW YORK
PHILADELPHIA / PORTLAND / RICHMOND / SAN ANTONIO / SAN JOSE / SEATTLE / TAMPA / WASHINGTON, DC



ANTINOZZI ASSOCIATES
ARCHITECTURE & INTERIORS

OWNER

Trumbull Public Schools
6254 Main Street
Trumbull, CT 06611

4	04/08/2014	ISSUED FOR BID
3	03/07/2014	ISSUED FOR BID
2	09/13/2013	ISSUED FOR BID
1	07/16/2013	ISSUED FOR REVIEW
No.	Date	Description

ISSUE

PROJECT
Fuel Oil Tank Replacement
Middlebrook Elementary School
220 Middlebrooks Ave.
Trumbull, CT 06611

DRAWING TITLE

MECHANICAL SCHEDULES AND DETAILS

Drawn By	JR	Drawing No.	M-400
Checked By	JM		
Date	07/16/2013		
Scale	N.T.S.		
Project No.	S130020-000		

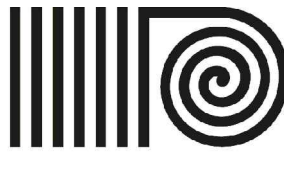


750 East Main Street, Suite 501
 Stamford, CT 06902
 T: 203.323.4333 F: 203.323.2999

ARLINGTON / BOSTON / MEXICO CITY / MINNEAPOLIS / NEW YORK
 PHILADELPHIA / PRINCETON / ROCHESTER / STAMFORD

ENGINEERING / ANALYSIS/TESTING / BUILDING MANAGEMENT SYSTEMS / CENTRAL UTILITIES
 CODE CONSULTING / COMMERCIAL / CRITICAL SYSTEMS / ENERGY SUSTAINABILITY
 INFRASTRUCTURE / PLANNING/DESIGN / BUILDING DESIGN / SPECIALTIES/DESIGNS

www.AKFGroup.com



ANTINOZZI ASSOCIATES
 ARCHITECTURE & INTERIORS

OWNER

Trumbull Public Schools
6254 Main Street
Trumbull, CT 06611

PROJECT

Fuel Oil Tank Replacement
Middlebrook Elementary School
220 Middlebrooks Ave.
Trumbull, CT 06611

DRAWING TITLE

MECHANICAL
SPECIFICATIONS

4	04/08/2014	ISSUED FOR BID
3	03/07/2014	ISSUED FOR BID
2	09/13/2013	ISSUED FOR BID
1	07/16/2013	ISSUED FOR REVIEW
No.	Date	Description
ISSUE		

Drawn By JR Checked By JM Date 07/16/2013 Scale N.T.S. Project No. S130020-000	Drawing No. M-500
--	--